

Appendix "A"

Owner Provided Drawings






Drawings in this section are approximate depictions of existing conditions which may be useful to Bidders.

These drawings are labeled "AS-BUILT" but are not guaranteed.

Bidders are **STRONGLY ADVISED** to independently inspect the existing structure, and accurately verify field conditions. The City will not be held responsible for incorrect measurements or assumptions.

1. Mechanical Drawing, M2, M4, M6 and M8.

1/16/75

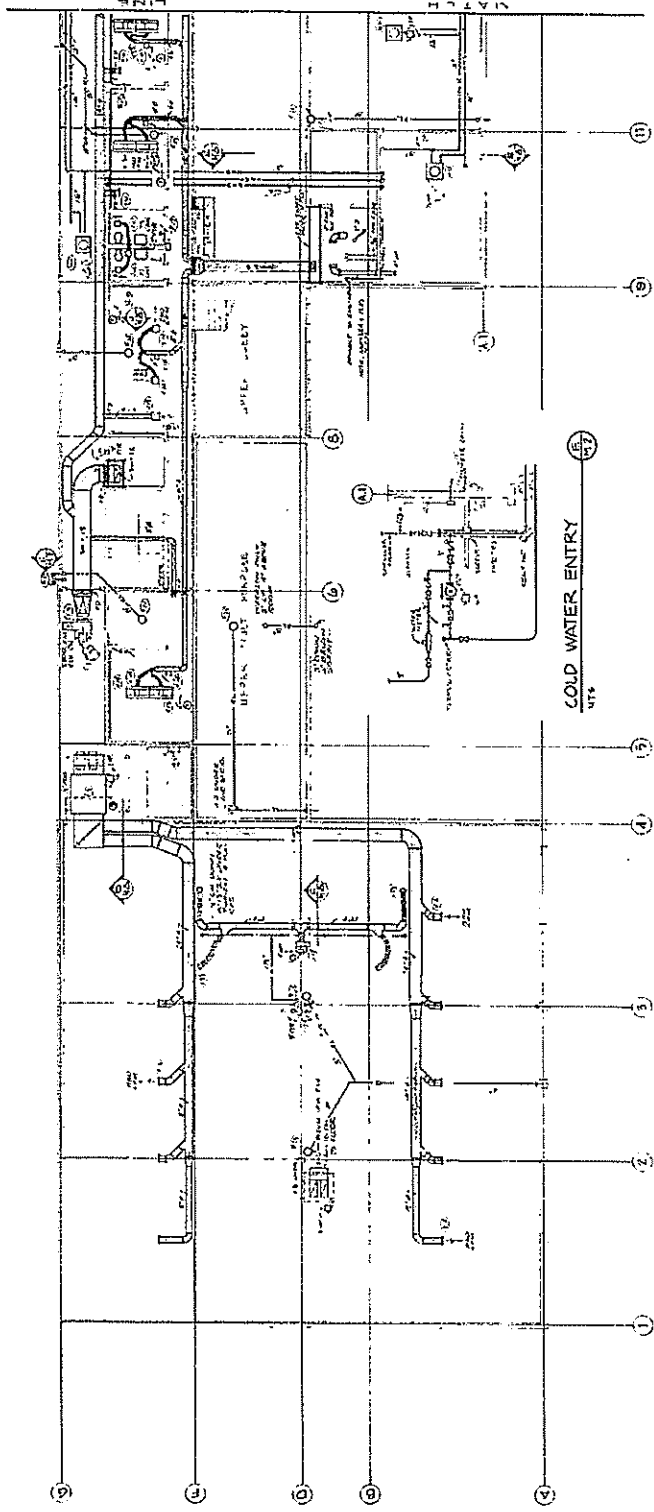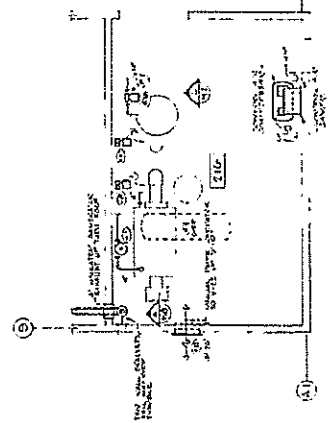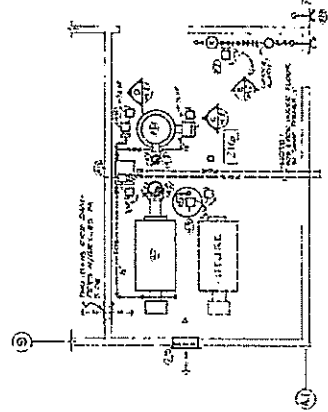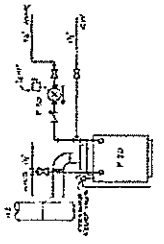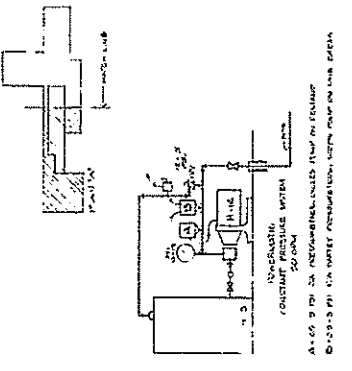

FLOOR PLAN A
SCALE: 1/4" = 1'-0"


 
M4
AS BUILT
9-23-79

Architects:
G.D.M. & Associates, inc.
Fairbanks, Alaska

REBID SET

City of Fairbanks
Public Works Garage
Davis and Peger Roads
Fairbanks, Alaska

DATE: 11-77

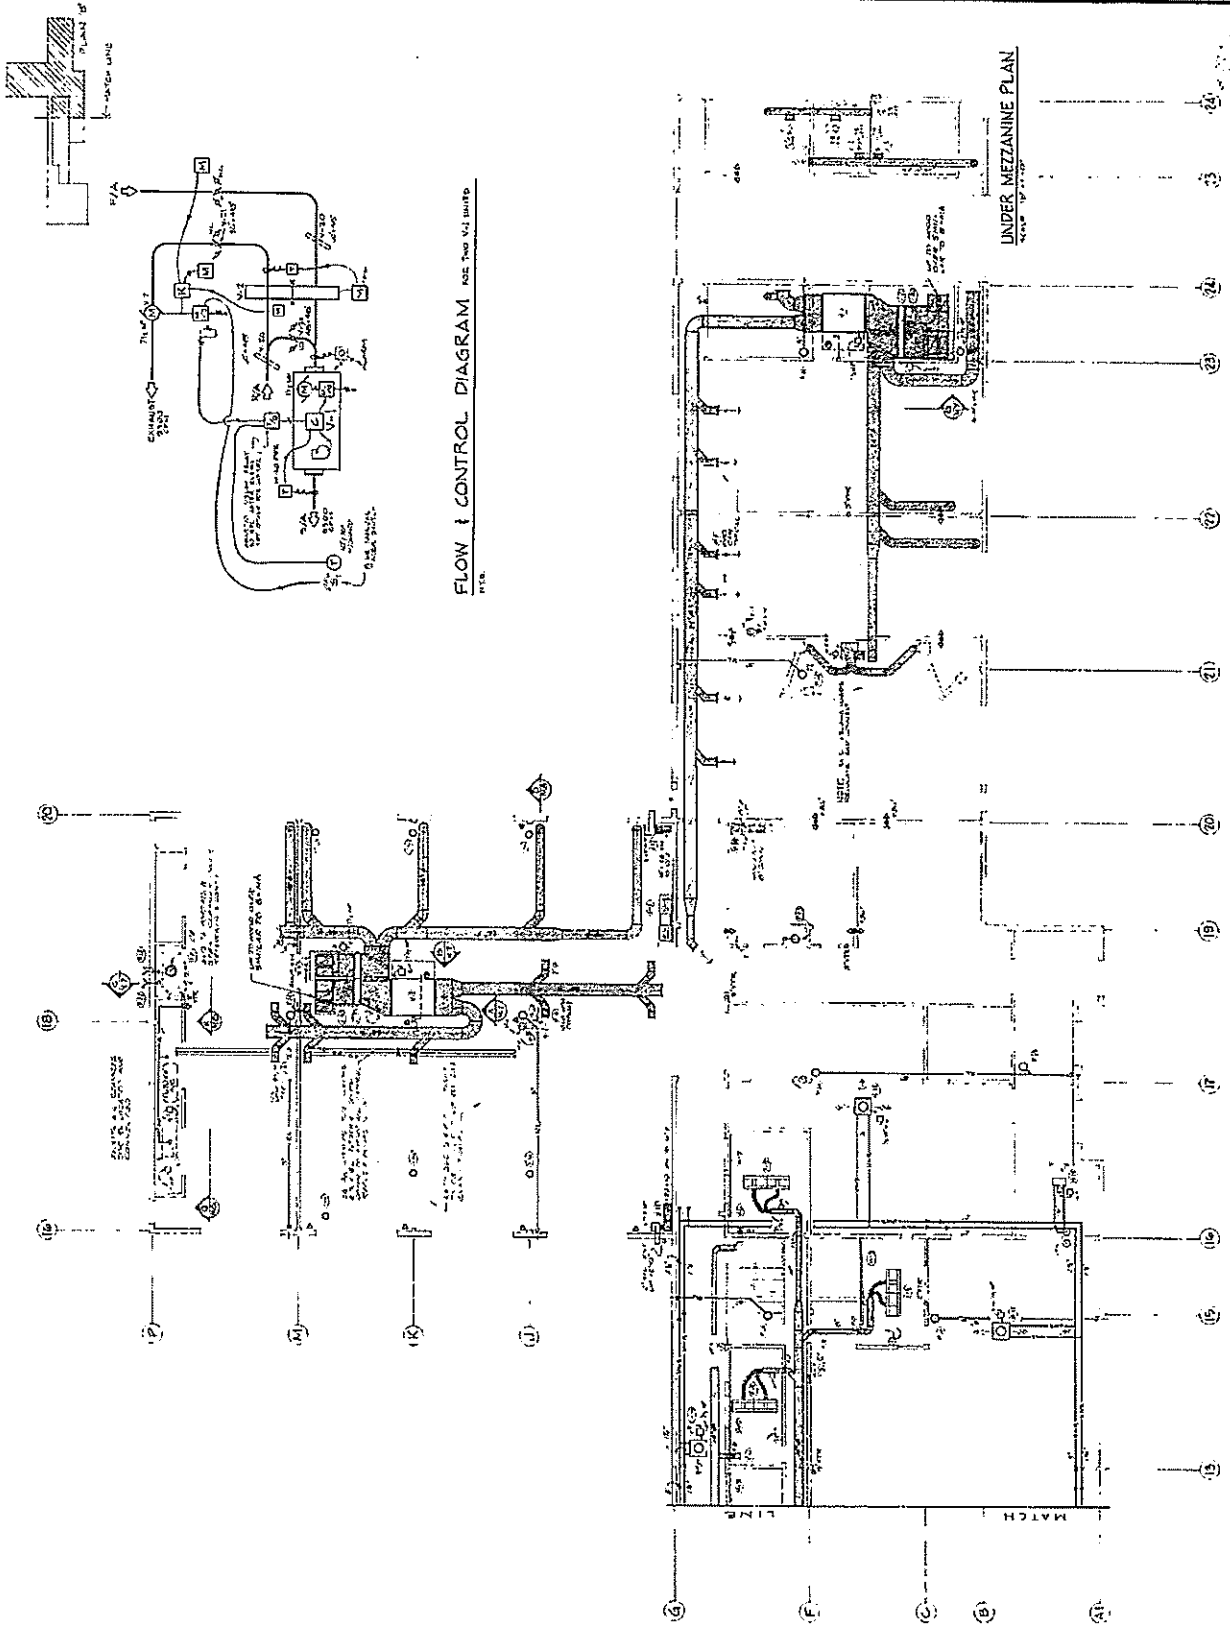

FLOOR PLAN 'B'
SCALE: 1/8" = 1'-0"

FLOW CONTROL DIAGRAM FOR TWO V.I. UNITS
SEE PAGES 11-12




FORM NO. 10-1-64 DATE 11-17-77

M5
AS BUILT
5-24-79




architects:
G.D.M. & Associates, Inc.
Fairbanks, Alaska

REBID SET

City of Fairbanks
Public Works Garage
Davis and Peger Roads Fairbanks, Alaska

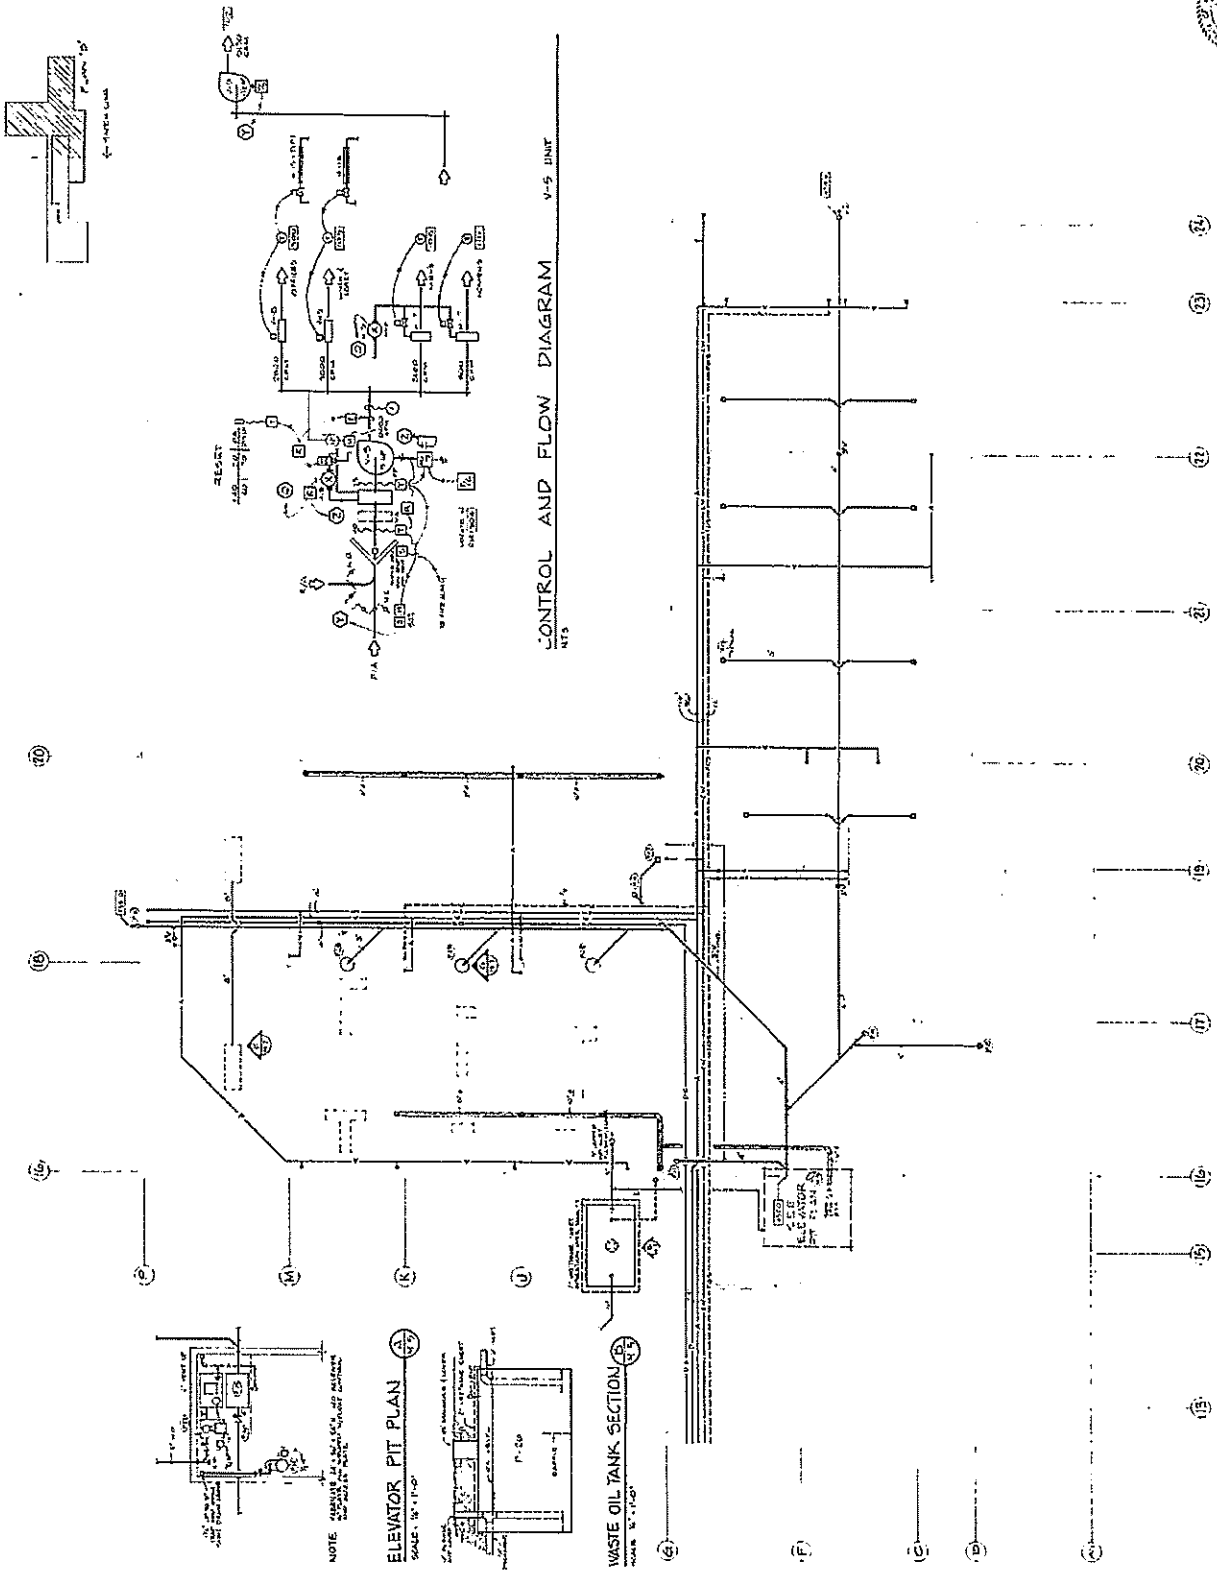

CONTROL AND FLOW DIAGRAM
NTS

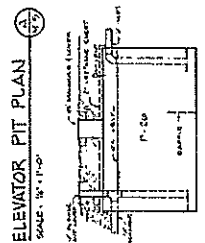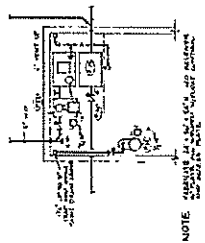 


NOTE: REFER TO ALL OTHER DRAWINGS FOR DETAILS.


UNDER FLOOR PLAN 'B'

SCALE: 1/2" = 1'-0"


DATE: 1-23-1977
JOB NO. T-68

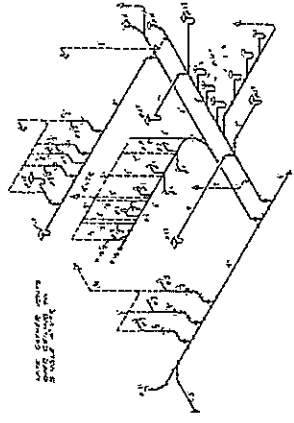

DWV DETAIL
NOTE

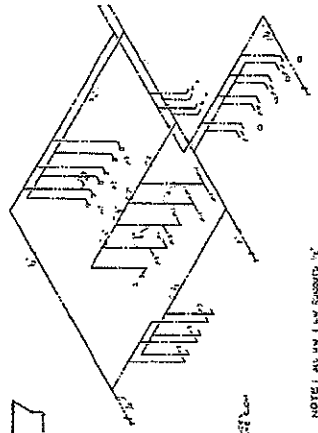


DWV DETAIL
NOTE


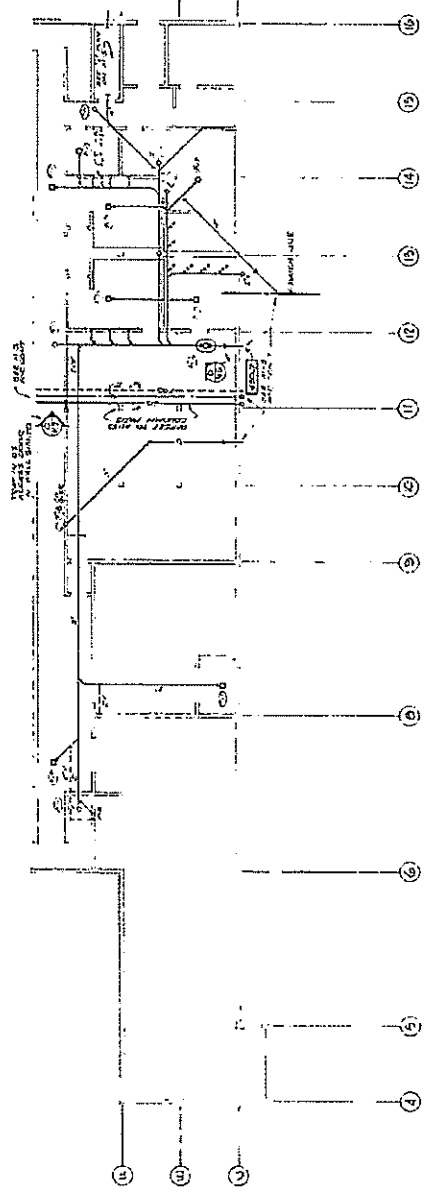


UNDER FLOOR PLAN 'C'
SCALE: 1/8" = 1'-0"

FLOOR PLAN 'C'
SCALE: 1/8" = 1'-0"

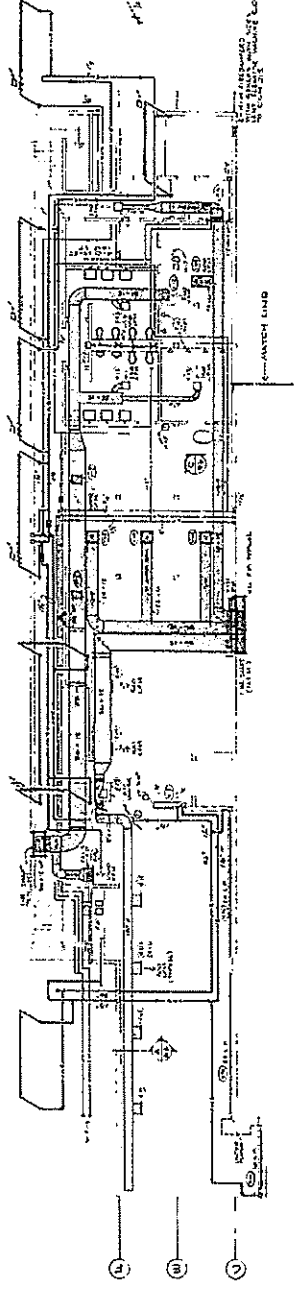

DWV DETAIL
SCALE: 1/8" = 1'-0"

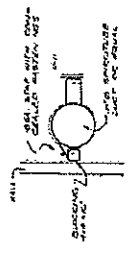 

SECTION
SCALE: 1/8" = 1'-0"




Architects:
G.D.M. & Associates, Inc.
 Fairbanks, Alaska


REBID SET

**City of Fairbanks
 Public Works Garage**
 Davis and Peger Roads, Fairbanks, Alaska


CEIL DIFFUSER DETAIL
 N.T.S.

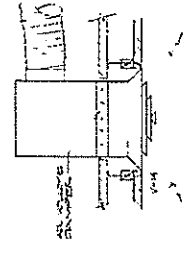


CHIMNEY ELEVATION
 N.T.S.

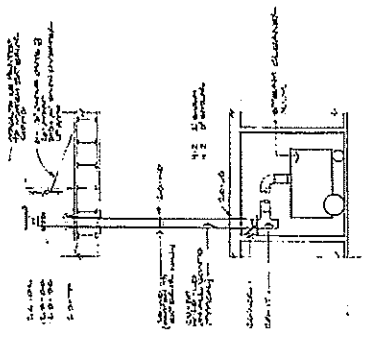


MECH. ROOM PLAN - UPPER
 SCALE: 1/4" = 1'-0"

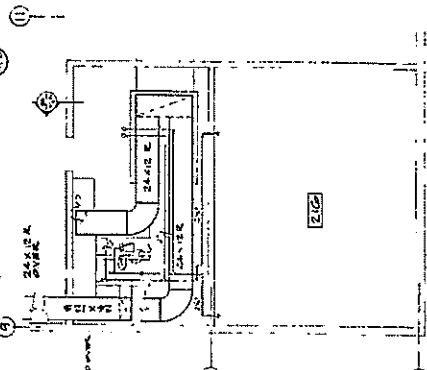


MECH. ROOM PLAN - LOWER
 SCALE: 1/4" = 1'-0"

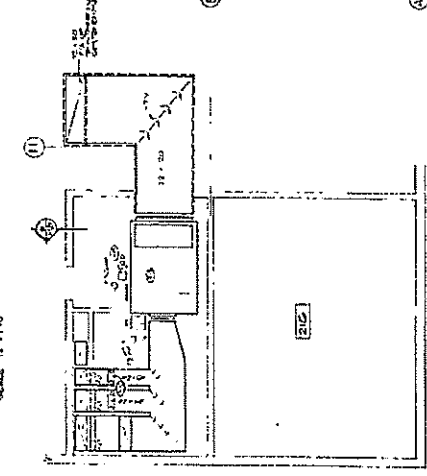


AIR COMPRESSOR DETAIL
 N.T.S.

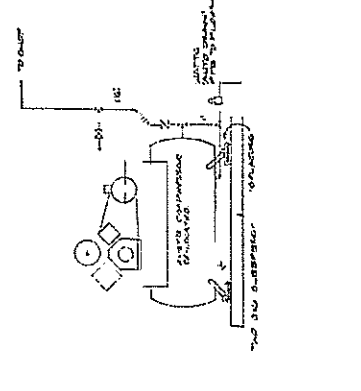


SECTION
 N.T.S.

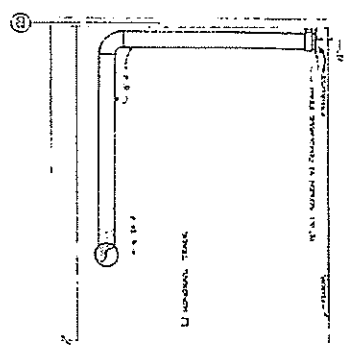

HEATING PIPING
 N.T.S.

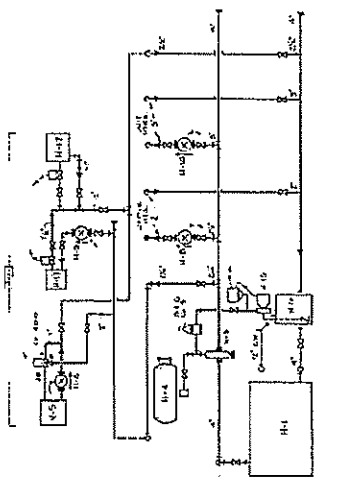

SECTION
 SCALE: 1/4" = 1'-0"

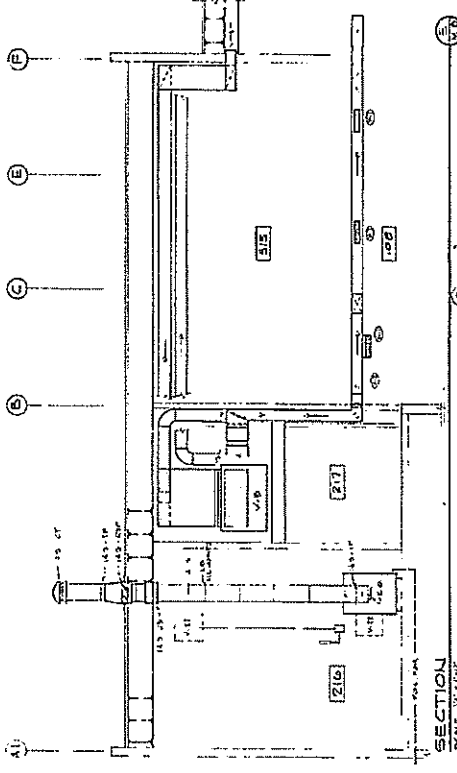

SECTION
 SCALE: 1/4" = 1'-0"

