


JANET MATHESON ARCHITECT

P.O. BOX 81038
FAIRBANKS,
ALASKA 99708
(907) 452-4640

**CITY OF FAIRBANKS
SENIOR CITIZENS RECREATION
& NUTRITION CENTER**

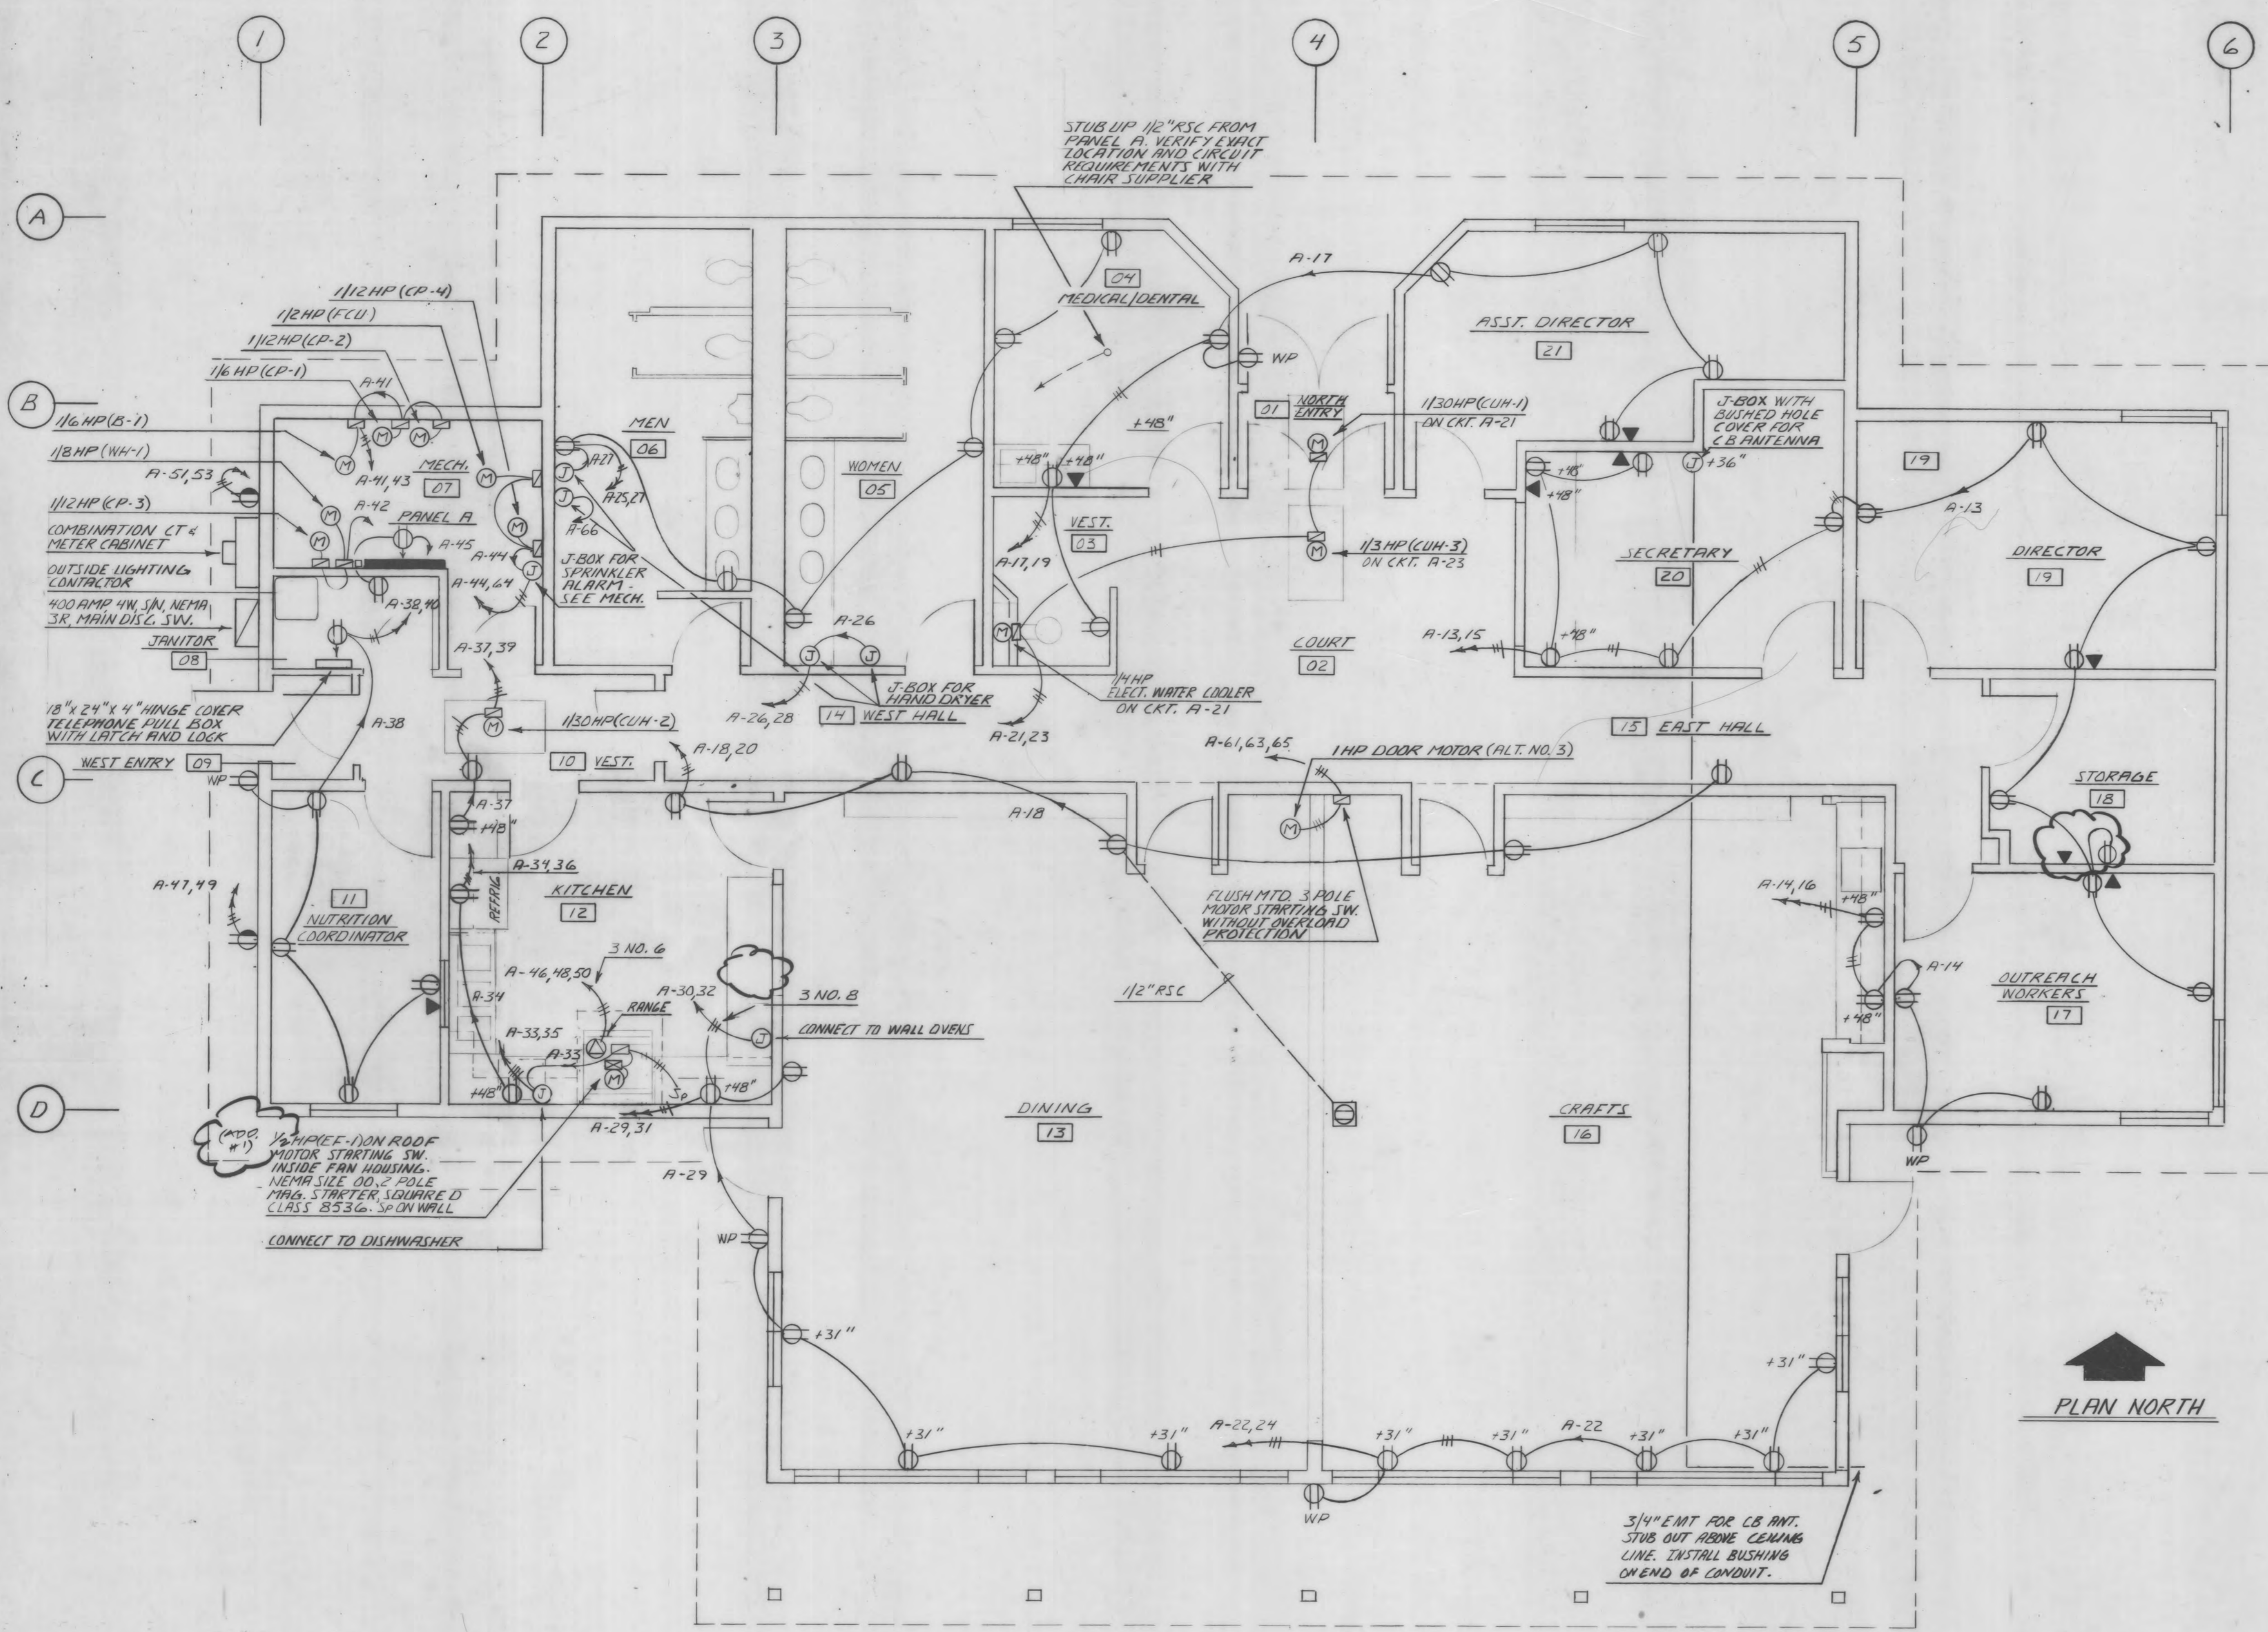

POWER PLAN
SCALE 1/4" = 1'-0"



POWER PLAN


REBID

SHT #

E-3

DOWN CE CKD

DATE 1/2/80 PROJ #

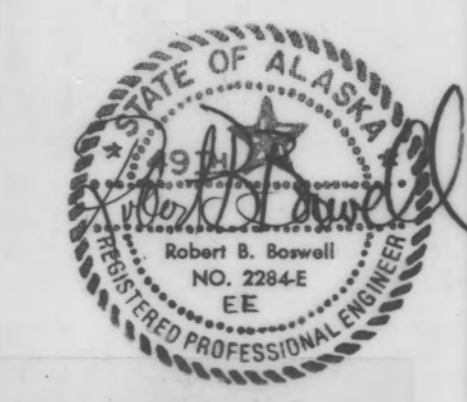

MICROFILMED
DATE: 12/83
MICROFILM NUMBER:

C6.0.148