



JANET MATHESON ARCHITECT
 P.O. BOX 81038
 FAIRBANKS,
 ALASKA 99708
 (907) 452-4640

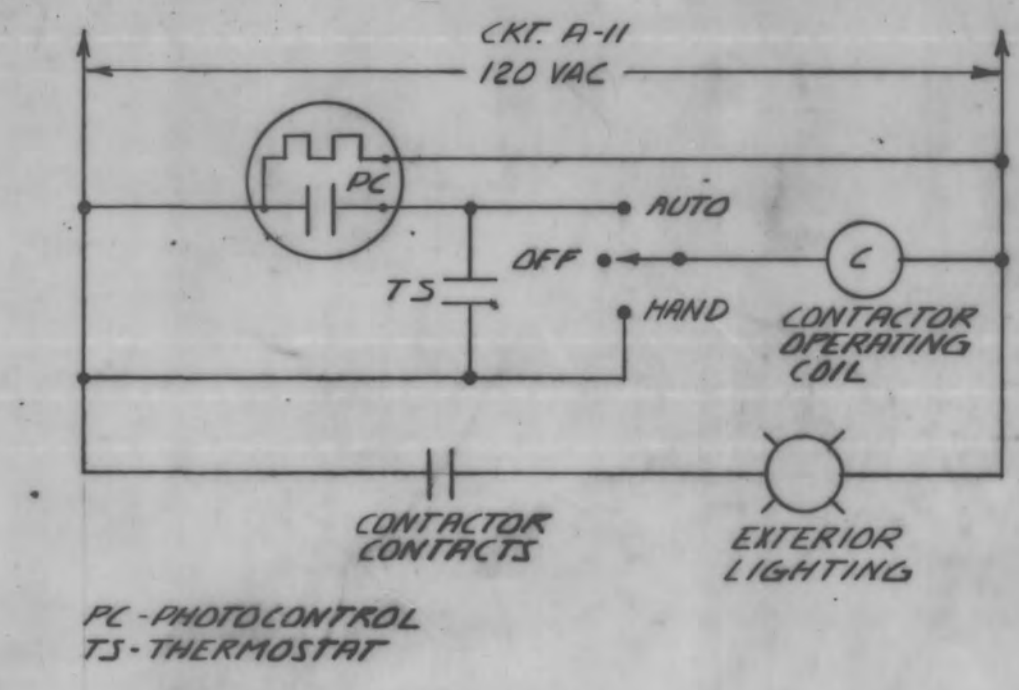


1
E-2
 OUTSIDE LIGHTING CONTROL DIAGRAM

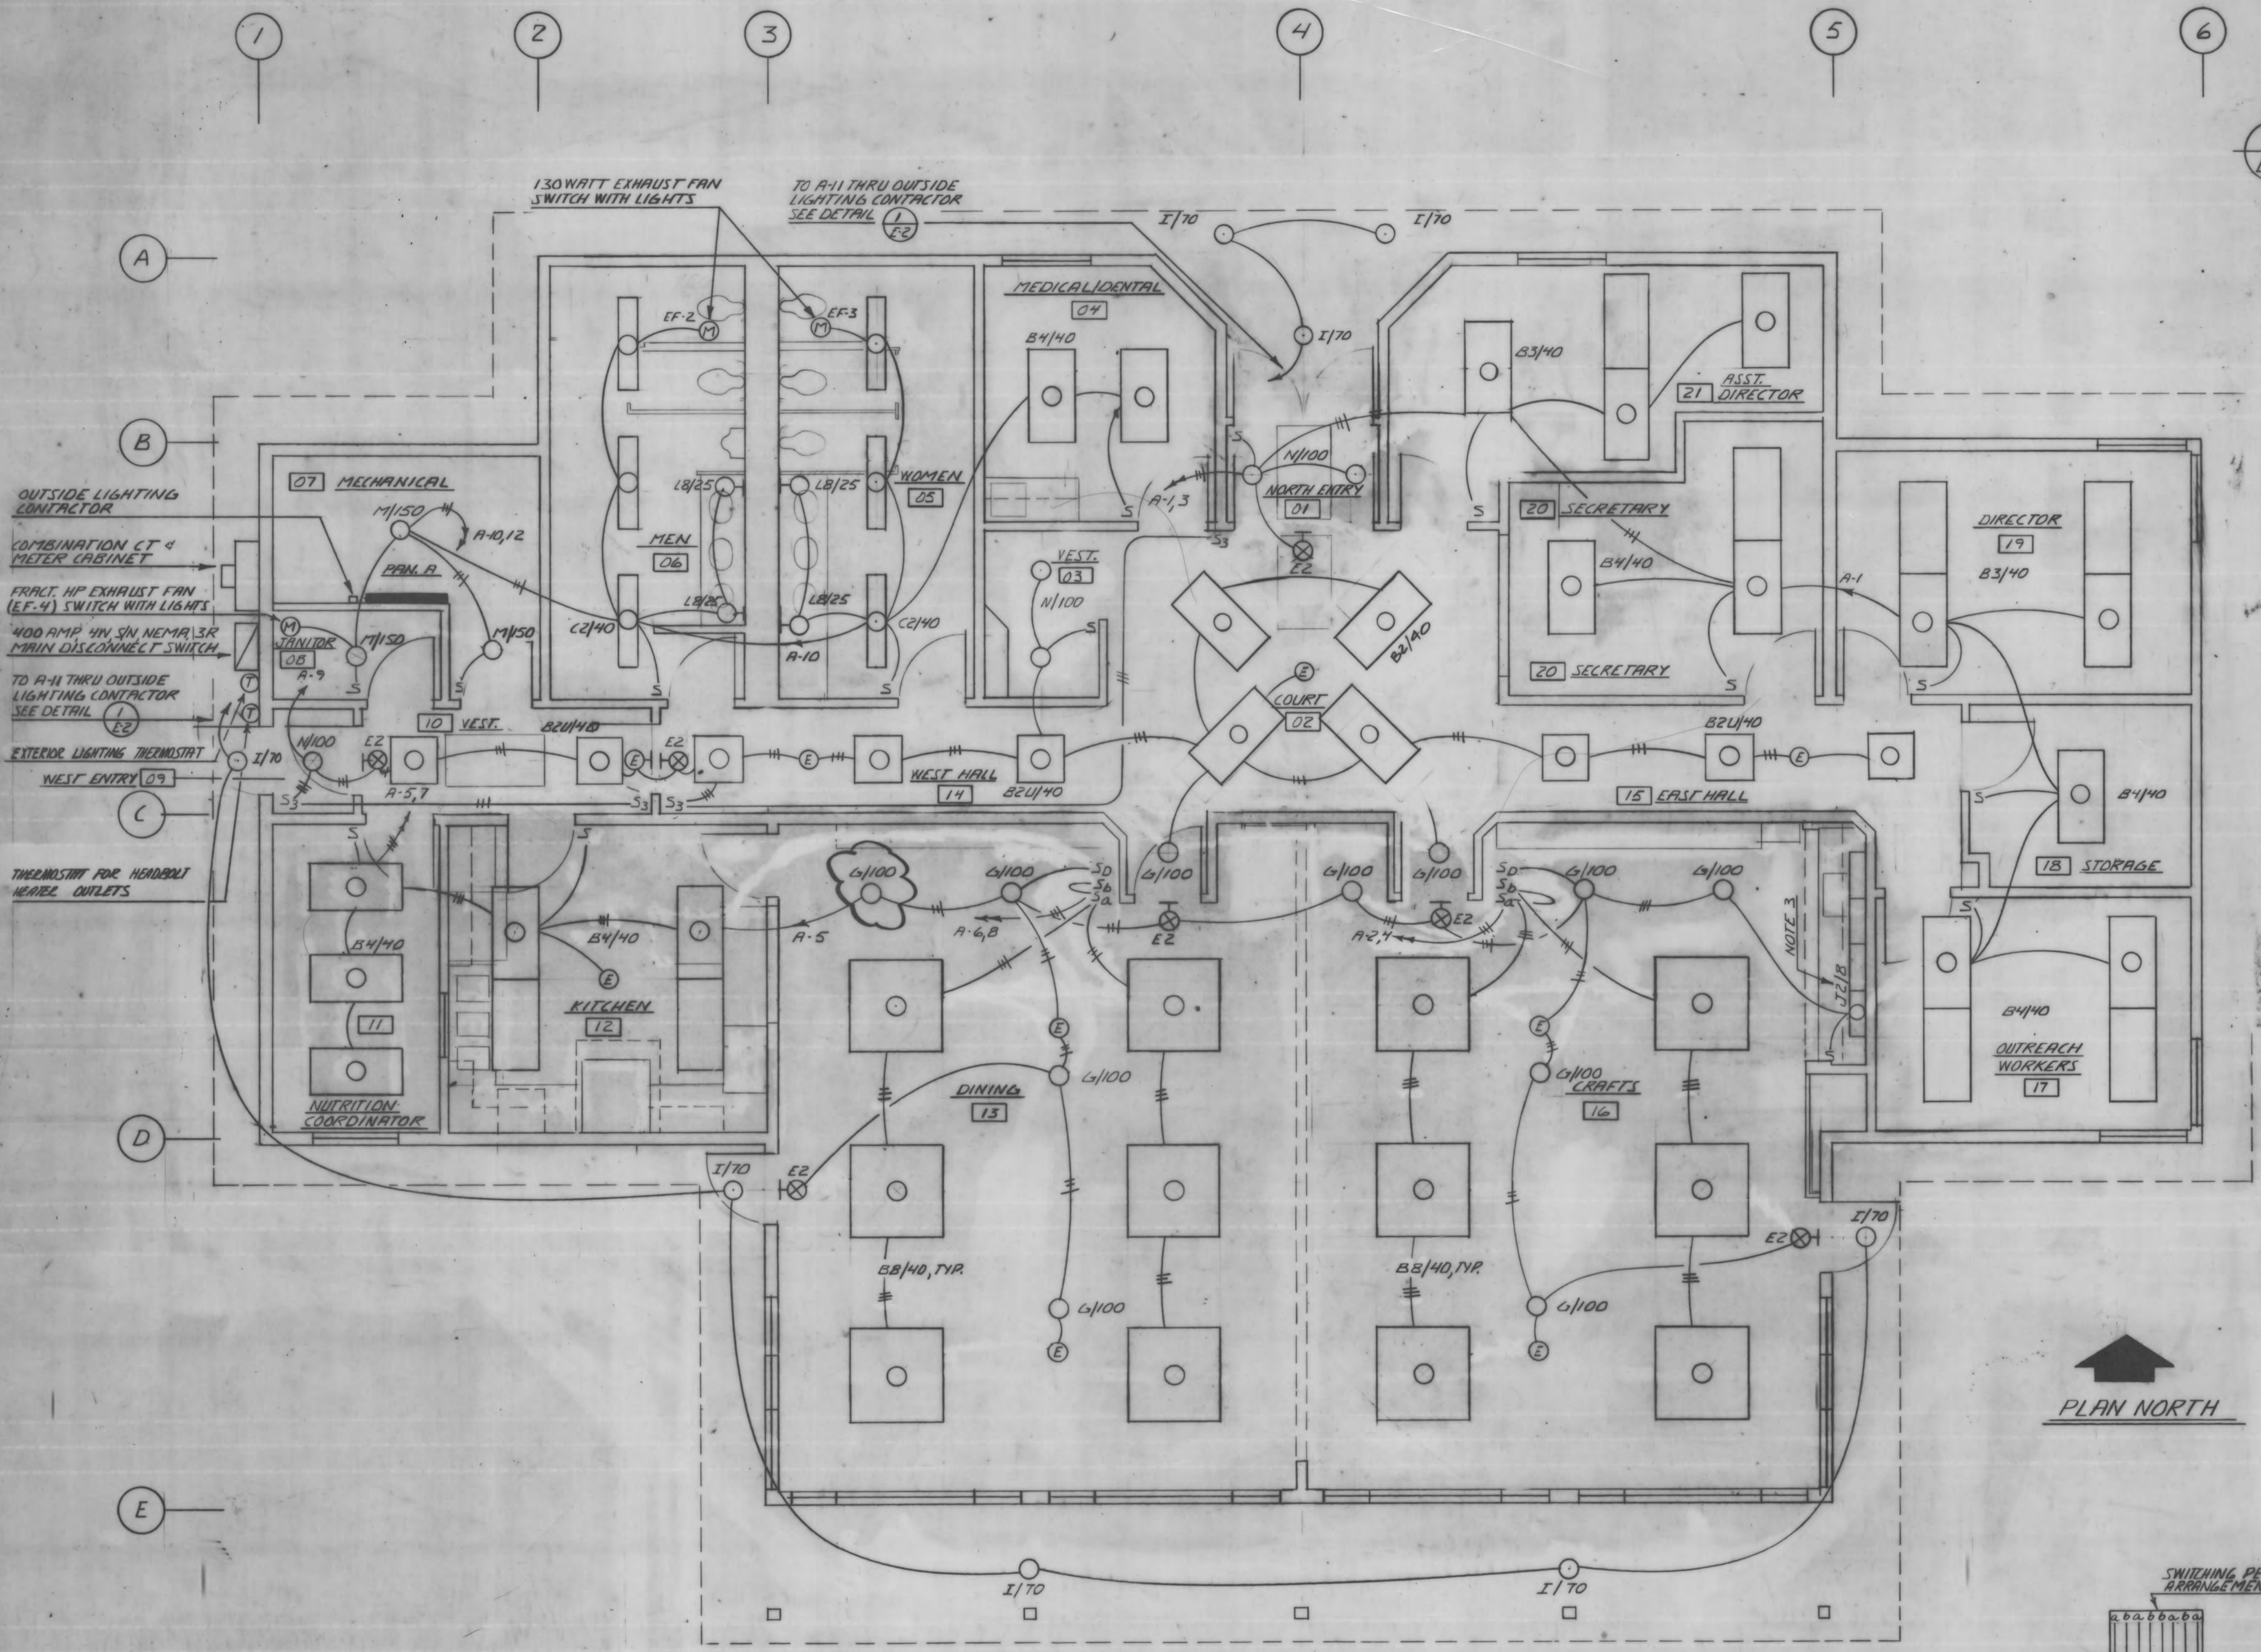

FIXTURE SCHEDULE			
TYPE	MOUNTING	LAMP	REMARKS
B2	SURFACE	F40/W/R/S/W	
B2U	SURFACE	F40/W/U	
B3	SURFACE	F40/W/R/S/W	
B4	SURFACE	F40/W/R/S/W	
C2	SURFACE	F40/W/R/S/W	
E2	WALL	20T6/DC/IF	PLUS TWO 6 VOLT NO. 82 LAMPS - MOUNT FIXTURE BOTTOM 2" ABOVE DOOR TRIM
F	SEMI-RECESSED	----	LAMP BY MANUFACTURER
G	RECESSED	100R/FL	
I	RECESSED	LU70/BU	
J2	SURFACE	F8T5/W	MOUNT FIXTURE UNDER CABINET TIGHT TO WALL - Note 3
K	WALL	LU100/BU	
L8	WALL	25G1 1/2/CW	
M	CEILING	150A23/99	
N	RECESSED	100R/FL	
O	POLE	LU250/BU	PROVIDE UNDER ADDITIVE ALTERNATE NO. 4

LIGHTING PLAN
 SCALE 1/4" = 1'-0"

PLAN - TYPE BB FIXTURES
 NO SCALE

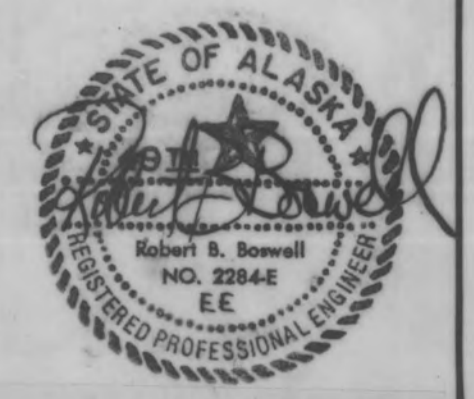

MICROFILMED
 DATE: 12/83
 MICROFILM NUMBER:

LIGHTING PLAN

REAR

SHT #

E-2

DWN CE CKD
 DATE: 7/2/80 PROJ #

C6.0.149