


**CITY OF FAIRBANKS
SENIOR CITIZENS RECREATION
& NUTRITION CENTER**



NOTE:
ALL PIPING & DUCTWORK RUN IN TRUSS SPACE EXCEPT FUEL OIL AND RAIN DRAIN FREEZE PROTECTION WHICH ARE BURIED.

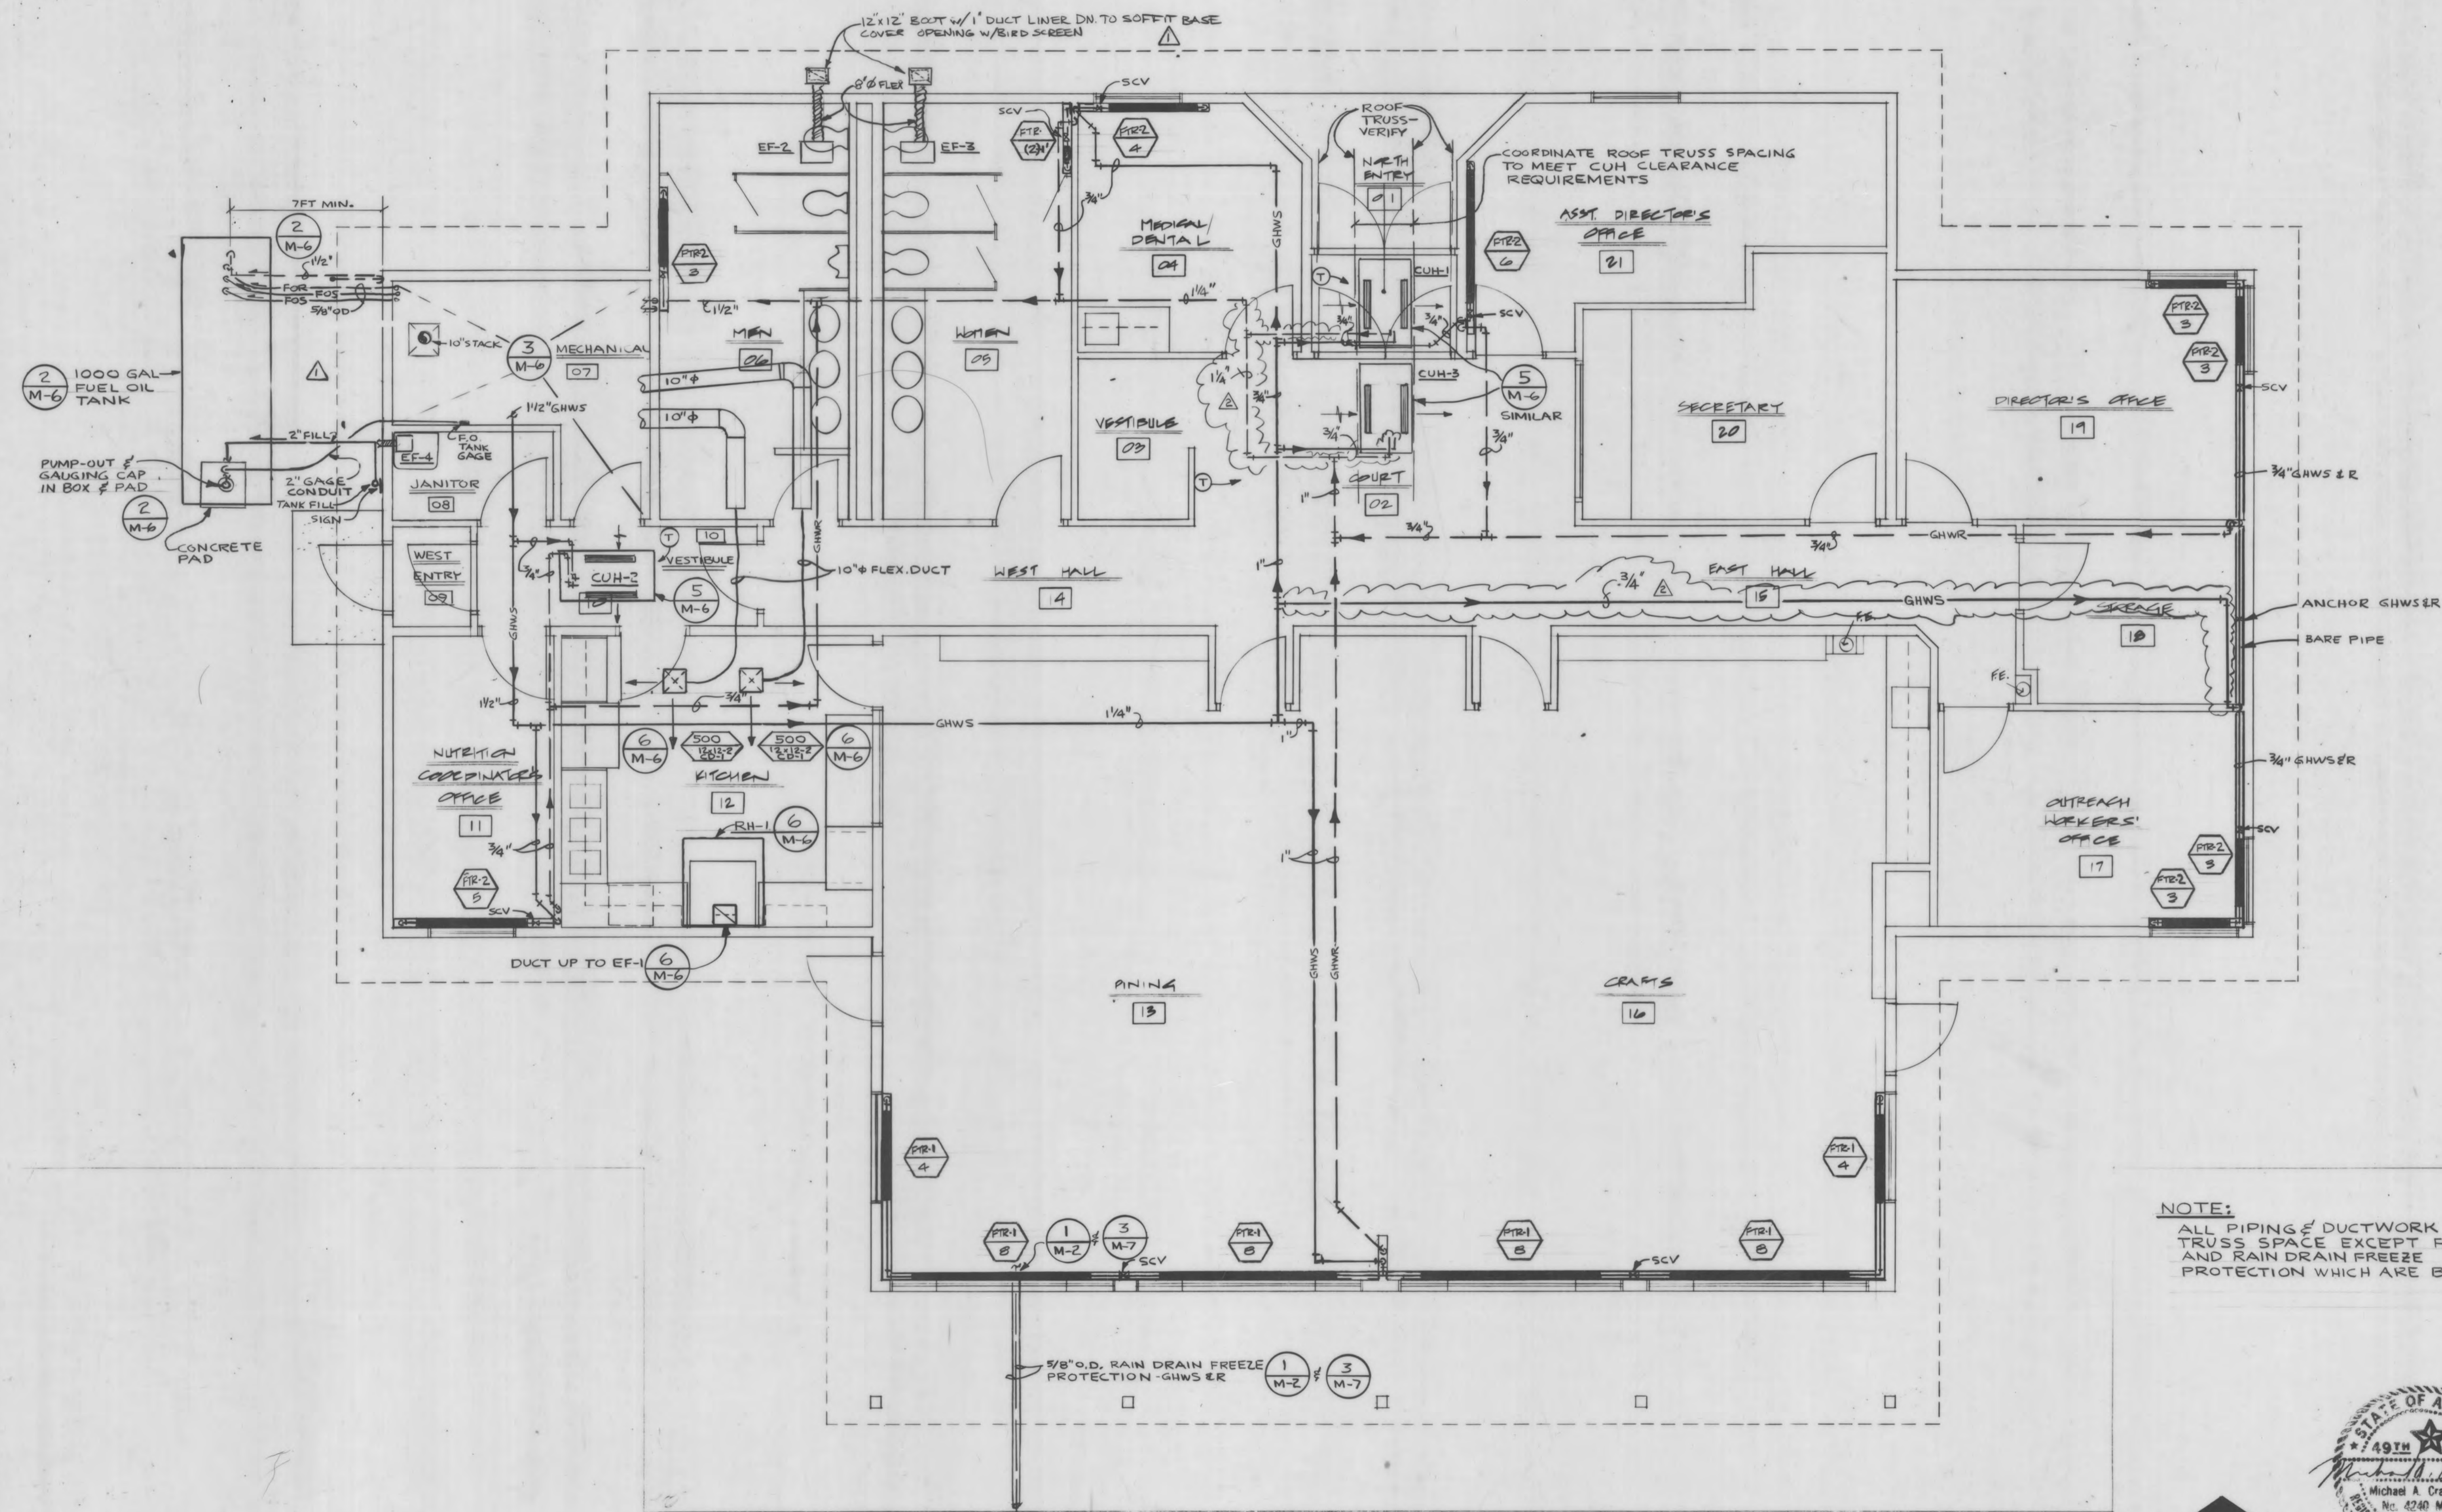

Ellerbe

MICROFILMED
DATE: 12/18/83
MICROFILM NUMBER:

AS BUILT 12-23-80
PROPOSED CHANGE ORDER #3 7/23/80

HVAC
FLOOR PLAN
REBID
SCALE: 1/4" = 1'-0"
SHT #

M5

DWN JWP CKD MAC
DATE: 1-80 PROJ #

CG.0.154