

CITY OF FAIRBANKS


PROJECT NO. 78-551

SENIOR CITIZENS RECREATION & NUTRITION CENTER

JANET MATHESON ARCHITECT
 P.O. BOX 81038
 FAIRBANKS, ALASKA 99708
 (907) 452-4640

VICINITY PLAN

SCALE: 1" = 50' @ 0"

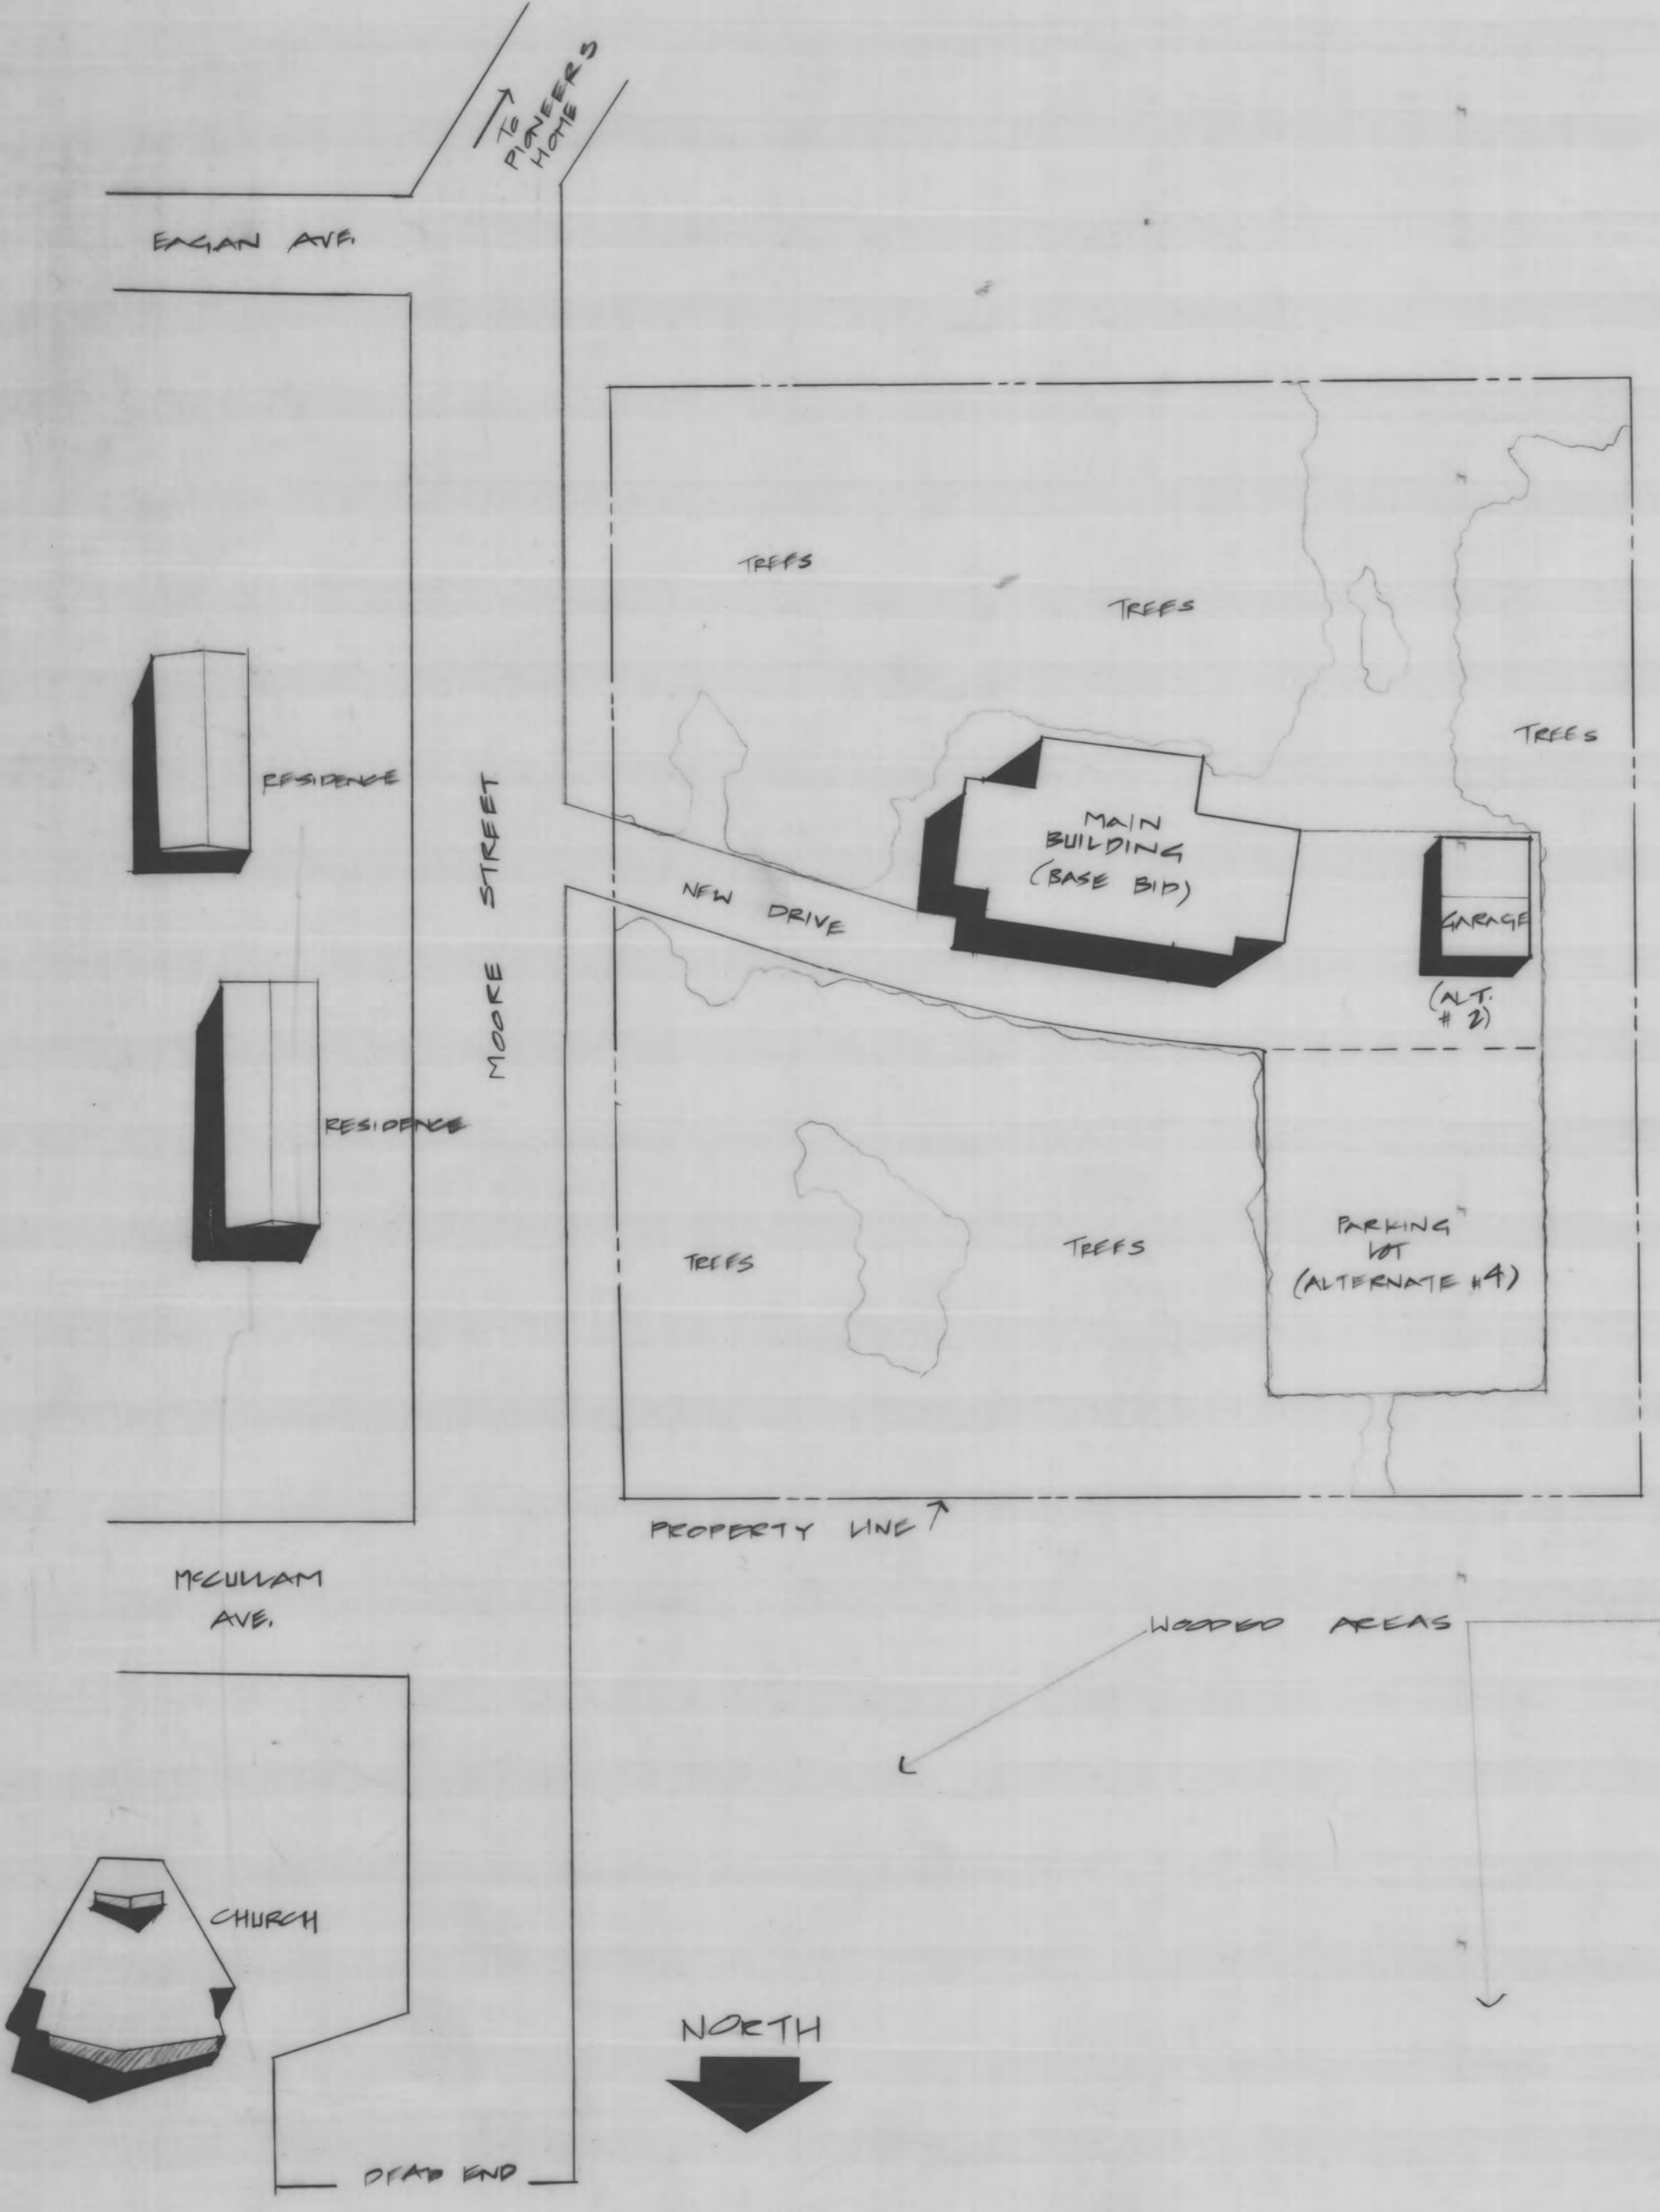

SYMBOLS

- CONCRETE
- CEMENT
- EARTH
- BATT INSULATION
- RIGID INSULATION
- PLYWOOD
- ACOUSTICAL TILE
- GRAVEL
- WOOD
- GYPSUM BOARD

SCHEDULE OF DRAWINGS

ARCHITECTURAL

- A1 MAIN BUILDING FLOOR PLAN
- A2 GARAGE - FLOOR PLAN & ROOF PLAN
- A3 ROOF PLAN & DETAILS
- A4 EXTERIOR ELEVATIONS
- A5 EXTERIOR ELEVATIONS
- A6 BUILDING SECTIONS
- A7 BUILDING SECTIONS
- A8 EXTERIOR WALL SECTIONS
- A9 INTERIOR ELEVATIONS
- A10 INTERIOR ELEVATIONS
- A11 INTERIOR ELEVATIONS & MIX. DETAILS
- A12 INTERIOR WALL SECTIONS & DETAILS
- A13 REFLECTED CEILING PLAN
- A14 EXTERIOR DETAILS
- A15 INTERIOR DETAILS
- A16 INTERIOR DETAILS
- A17 FINISH & DOOR SCHEDULES

MECHANICAL

- M1 MECHANICAL SITE PLAN
- M2 PLUMBING FOUNDATION PLAN
- M3 PLUMBING FLOOR PLAN
- M4 PLUMBING DETAILS
- M5 HVAC FLOOR PLAN
- M6 HVAC DETAILS
- M7 HVAC DETAILS
- M8 MECHANICAL LEGEND & EQUIPMENT SCHEDULE

ELECTRICAL

- E1 SITE PLAN SYMBOLS DETAILS & RISER DIAGRAMS
- E2 LIGHTING PLAN
- E3 POWER PLAN
- E4 GARAGE PLAN & PANEL SCHEDULES

STRUCTURAL/CIVIL

- C1 SITE PLAN
- S1 1ST FLOOR FRAMING & FOUNDATION PLAN, SECTIONS & DETAILS
- S2 ROOF FRAMING PLAN, SECTIONS & DETAILS
- S3 GARAGE: FOUNDATION & ROOF FRAMING PLANS, SECTIONS & DETAILS


CODE INFORMATION

FIRE ZONE: 3
 PLANNING ZONE: BUSINESS II (CONFORMING USE)
 CODE REFERENCE: 1977 UNIFORM BUILDING CODE, MECHANICAL CODE & PLUMBING CODE
 1978 NATIONAL ELECTRICAL CODE
 9-PL-78 STATE "INTERIM REGULATIONS FOR BARRIER-FREE FACILITIES"
 CONSTRUCTION TYPE: TYPE V - NON-RATED

| | ALLOWABLE AREA | PLANNED AREA |
|-------------------------------|----------------|----------------------|
| OCCUPANCY: A3 (DINING/CRAFTS) | 6000 SQ. FT. | 1530 SQ. FT. |
| B2 (OFFICES) & OTHER AREAS | 6000 SQ. FT. | 1324 SQ. FT. |
| | | TOTAL = 3704 SQ. FT. |

OCCUPANT LOAD: DINING/CRAFTS = 90
 OFFICES = 9
 TOTAL = 99

BUILDING HEIGHT: 1 STORY

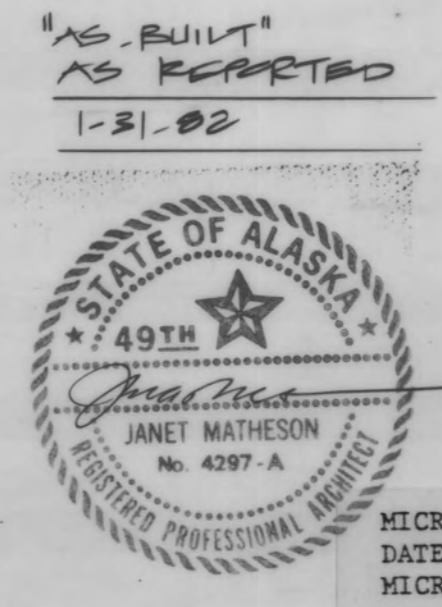

MICROFILMED
 DATE: 2/83
 MICROFILM NUMBER: CG.O.180

**CITY OF FAIRBANKS
 SENIOR CITIZENS RECREATION
 & NUTRITION CENTER**

TITLE
 SHEET

SHT #

REBID

DWN JN CKD
 DATE: 2-23-83 PROJ: 711
 CG.O.180