



1 EXISTING MECH. RM NORTH ELEVATION
 M-4 1/2" = 1'-0"

EQUIPMENT SCHEDULE						
SYMBOL	DESCRIPTION	DESIGN CRITERIA & BASE OF DESIGN	HP	V	PH	REMARKS
FTR-1	FINNED TUBE RADIATION	TRANE 1GTA 5/8 FIN W/O DAMPER	-	-	-	TO MATCH EXISTING
FTR-2	FINNED TUBE RADIATION	TRANE 1GTA 5/8 FIN W/O DAMPER WITH BOTTOM INLET GRILLE	-	-	-	TO MATCH FTR-1
CP-5	HTG. CIRCULATING PUMP	19 GPM @ 15.0 FT HD BELL & GOSSETT LD-3 BOOSTER	1/4	110	1	TO MATCH EXISTING
CUH-4	CABINET UNIT HEATER	TRANE M46 AD 02-63-H04	1/60	110	1	TO MATCH EXISTING
CV-3	CONTROL VALVE	HONEYWELL VE013A 1203 W/MOD. MOTOR, XFORMER & O.A. RESET CONTROLLER 1.5 TO 1.0 RESET RATIO 110F BASE TEMP.	-	110	1	TO MATCH EXISTING
EF-5	EXHAUST FAN	NOTONE FAN/LIGHT GRIP-ININATION 8672 N, 90 GPM @ 1/8 S.P.	170	110	1	USES 2 60 W LAMPS
EF-6	EXHAUST FAN	250 CFM @ 1/4" ESP PENN ZEPHYR MODEL 2-10 W/GRILLE	130W	110	1	

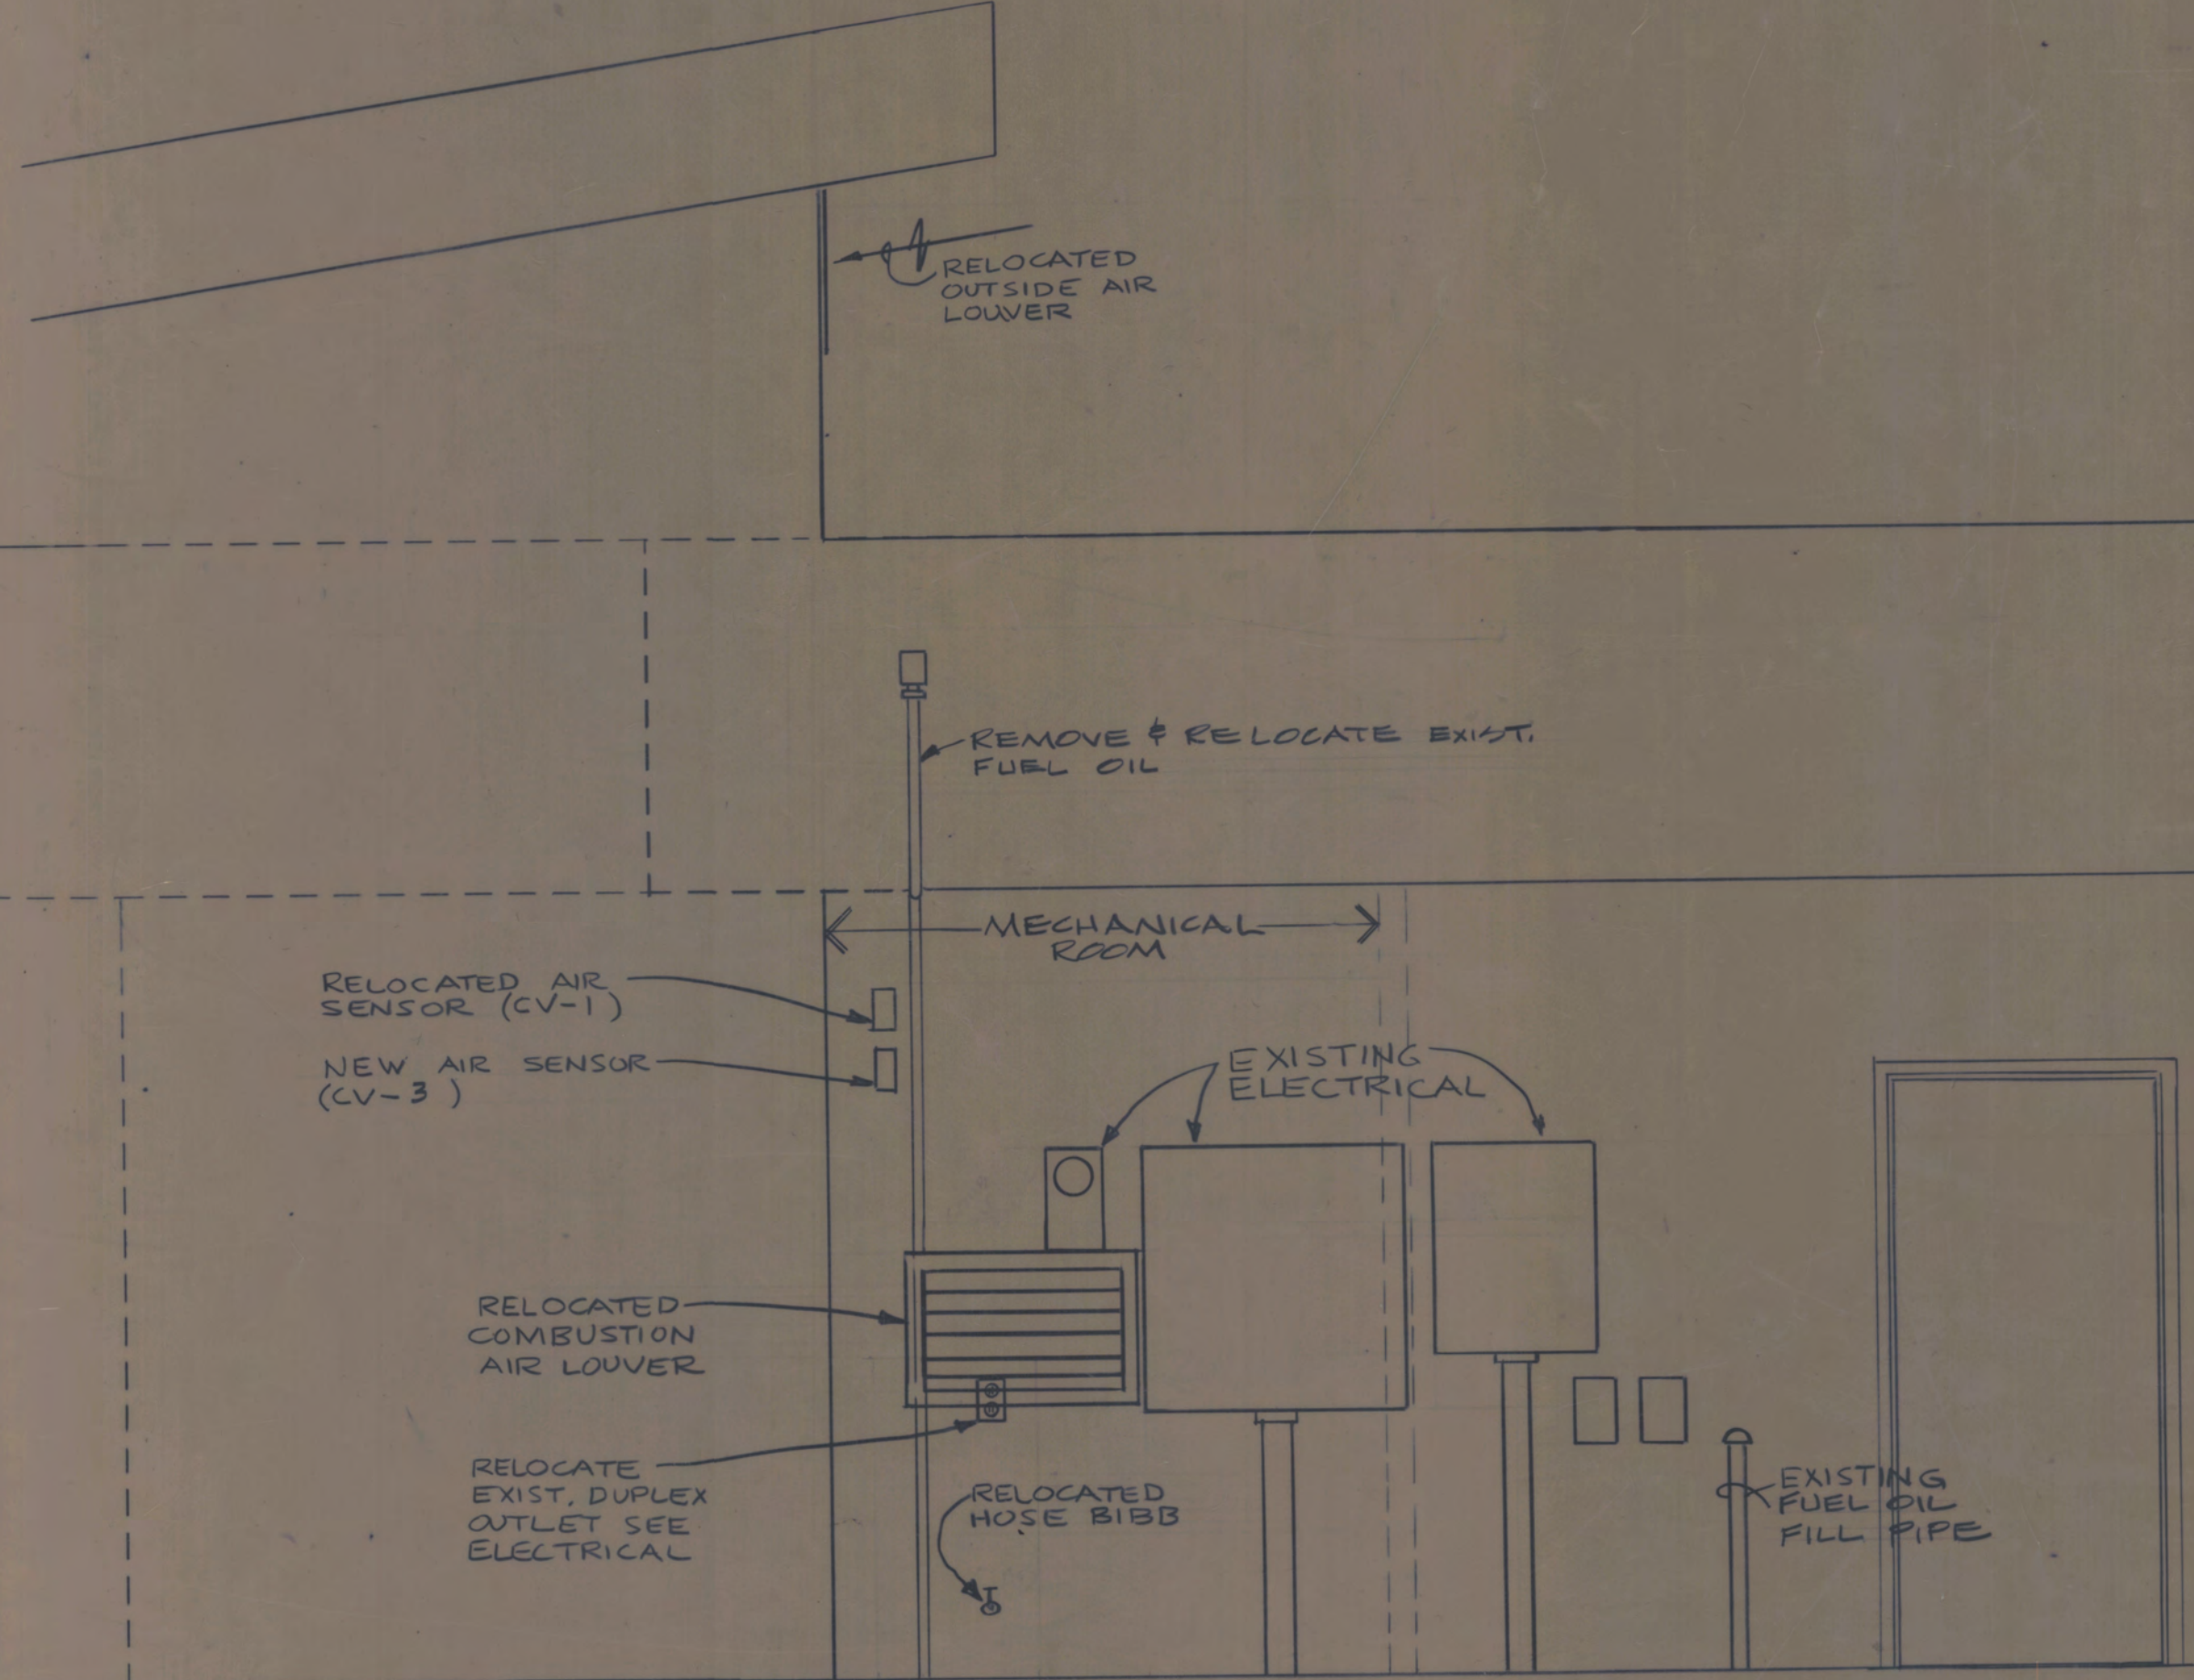

2 PARTIAL EXISTING WEST ELEVATION
 M-4 1/2" = 1'-0"

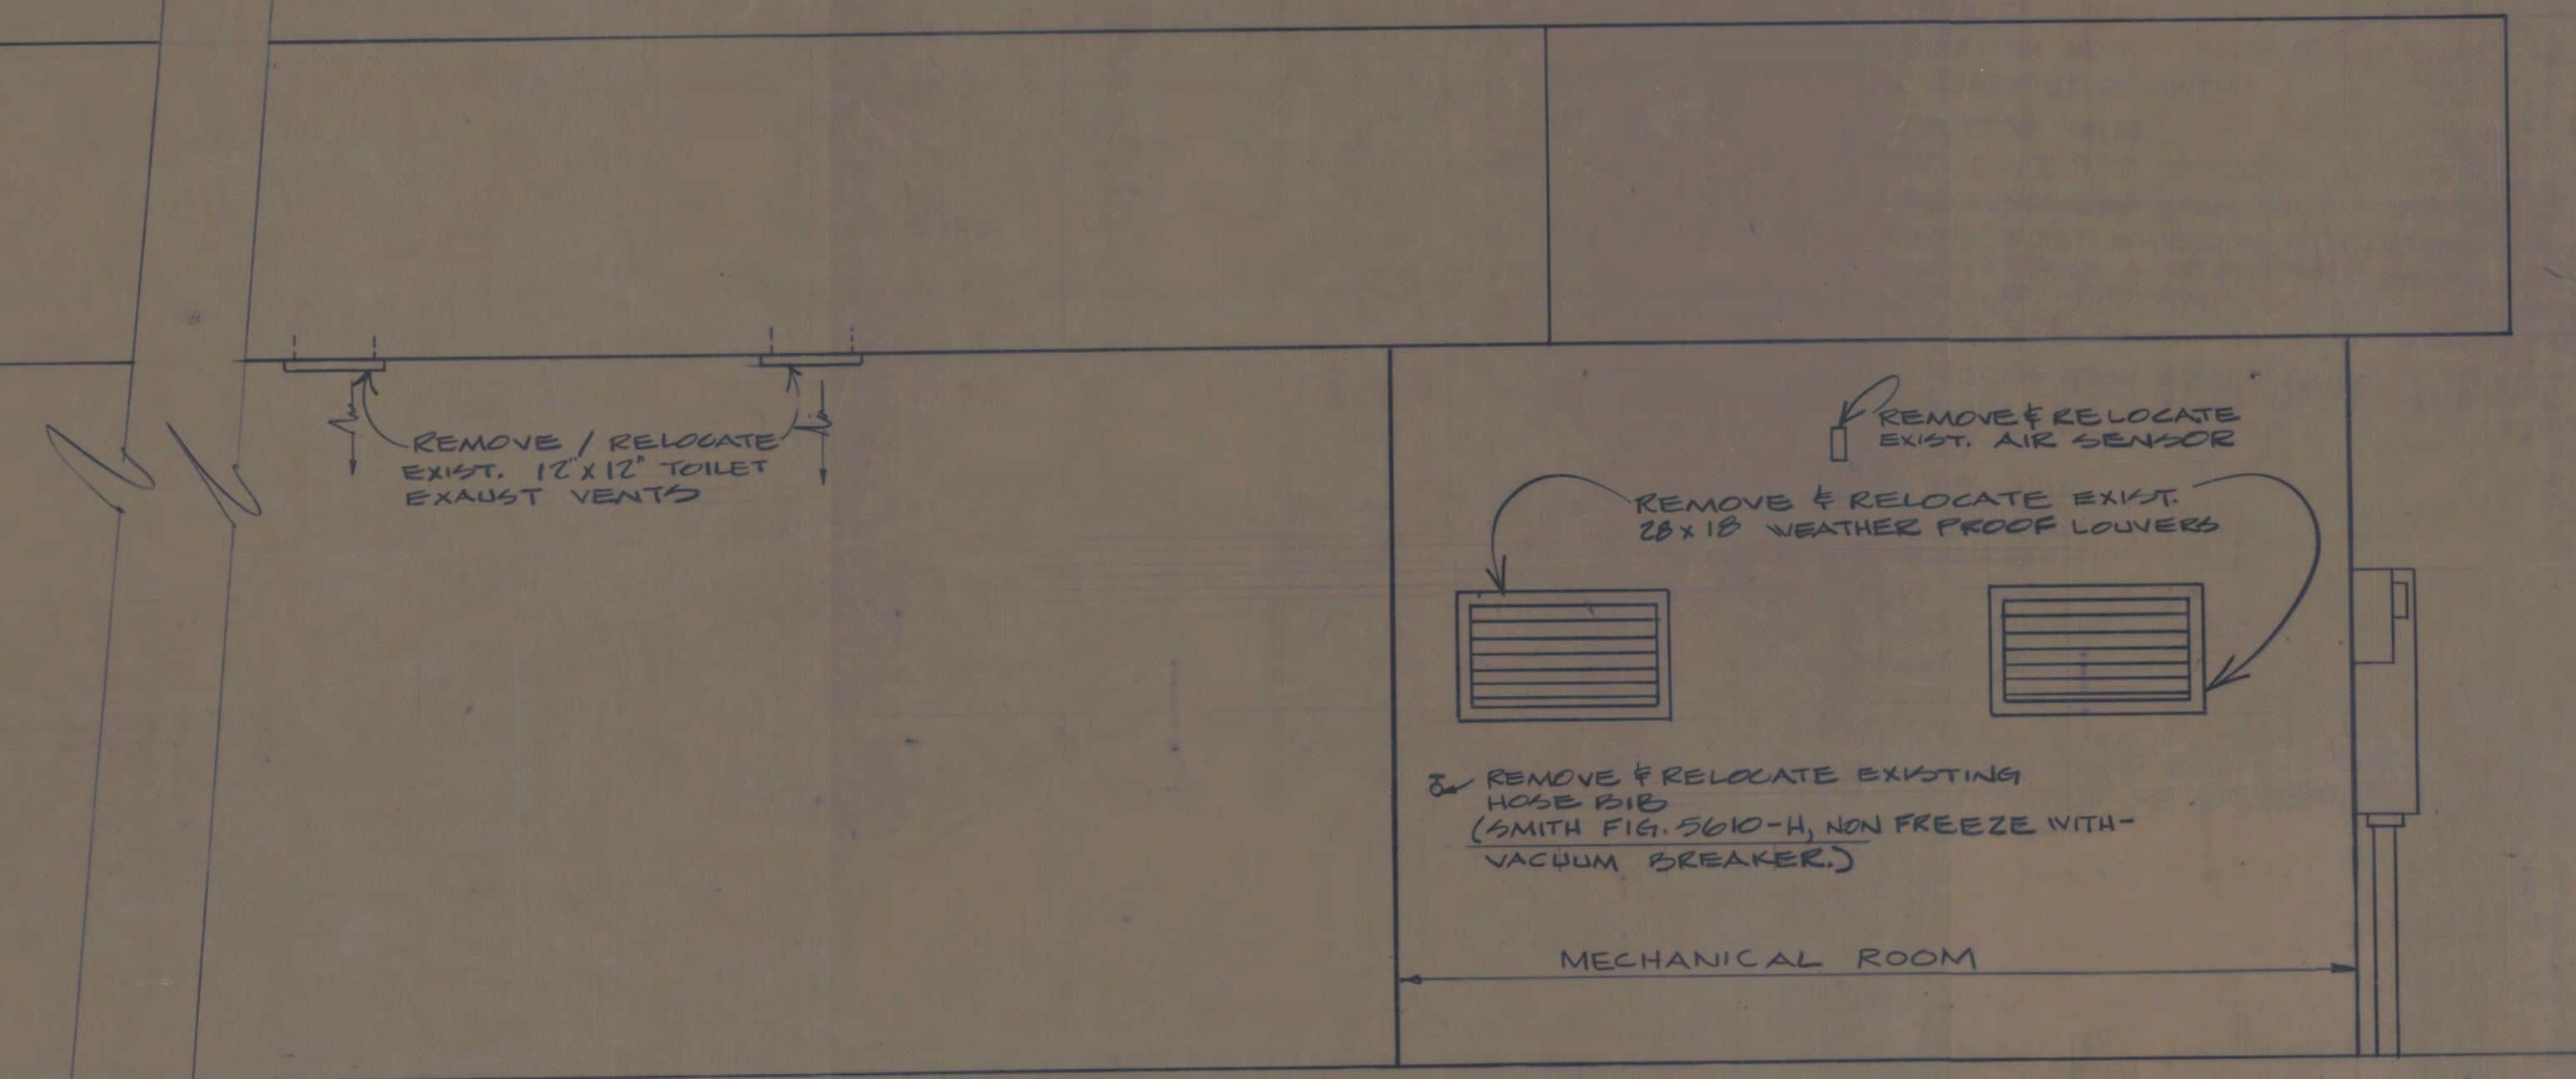

3 PARTIAL EXIST. NORTH ELEVATION
 M-4 1/2" = 1'-0"

ENG7943.TIF



SUN FAIR ENGINEERING FAIRBANKS, ALASKA



C. LEMARCHAND KENNEDY AND ASSOCIATES:
envirodesign
 ARCHITECTURE, PLANNING, ENERGY MANAGEMENT
 1327 KALAKANET, FAIRBANKS, ALASKA 99701 (907) 479-3193

REVISIONS:
 PROJECT NO.
 DATE: 7/31/84
 DRAWN: SW/AMAL
 CHECKED: MCL
 CONTENTS:
 MECHANICAL ELEVATIONS & SCHEDULES
 SCALE: 1/2" = 1'-0"

CITY OF FAIRBANKS
 SENIOR CITIZENS RECREATION & NUTRITION CENTER
 ADDITION

DRAWING NO.
 M-4
 05-4

F8-00001