



C. LEMARCHAND KENNEDY AND ASSOCIATES:  
**enviro**design  
 ARCHITECTURE, PLANNING, ENERGY MANAGEMENT  
 1327 KALAKAKE, FAIRBANKS, ALASKA 99701 (907) 478-3193

REVISIONS:  
 PROJECT NO.  
 DATE: 7/31/86  
 DRAWN: EW  
 CHECKED: WJC

CONTENTS:  
 UNDERFLOOR PLUMBING  
 HEATING PLAN  
 SCALE: 1/4" = 1'-0"


CITY OF FAIRBANKS  
 SENIOR CITIZENS RECREATION  
 & NUTRITION CENTER  
 ADDITION

DRAWING NO.  
 M-1  
 094



SUN FAIR  
 ENGINEERING  
 FAIRBANKS, ALASKA

F8.0.034

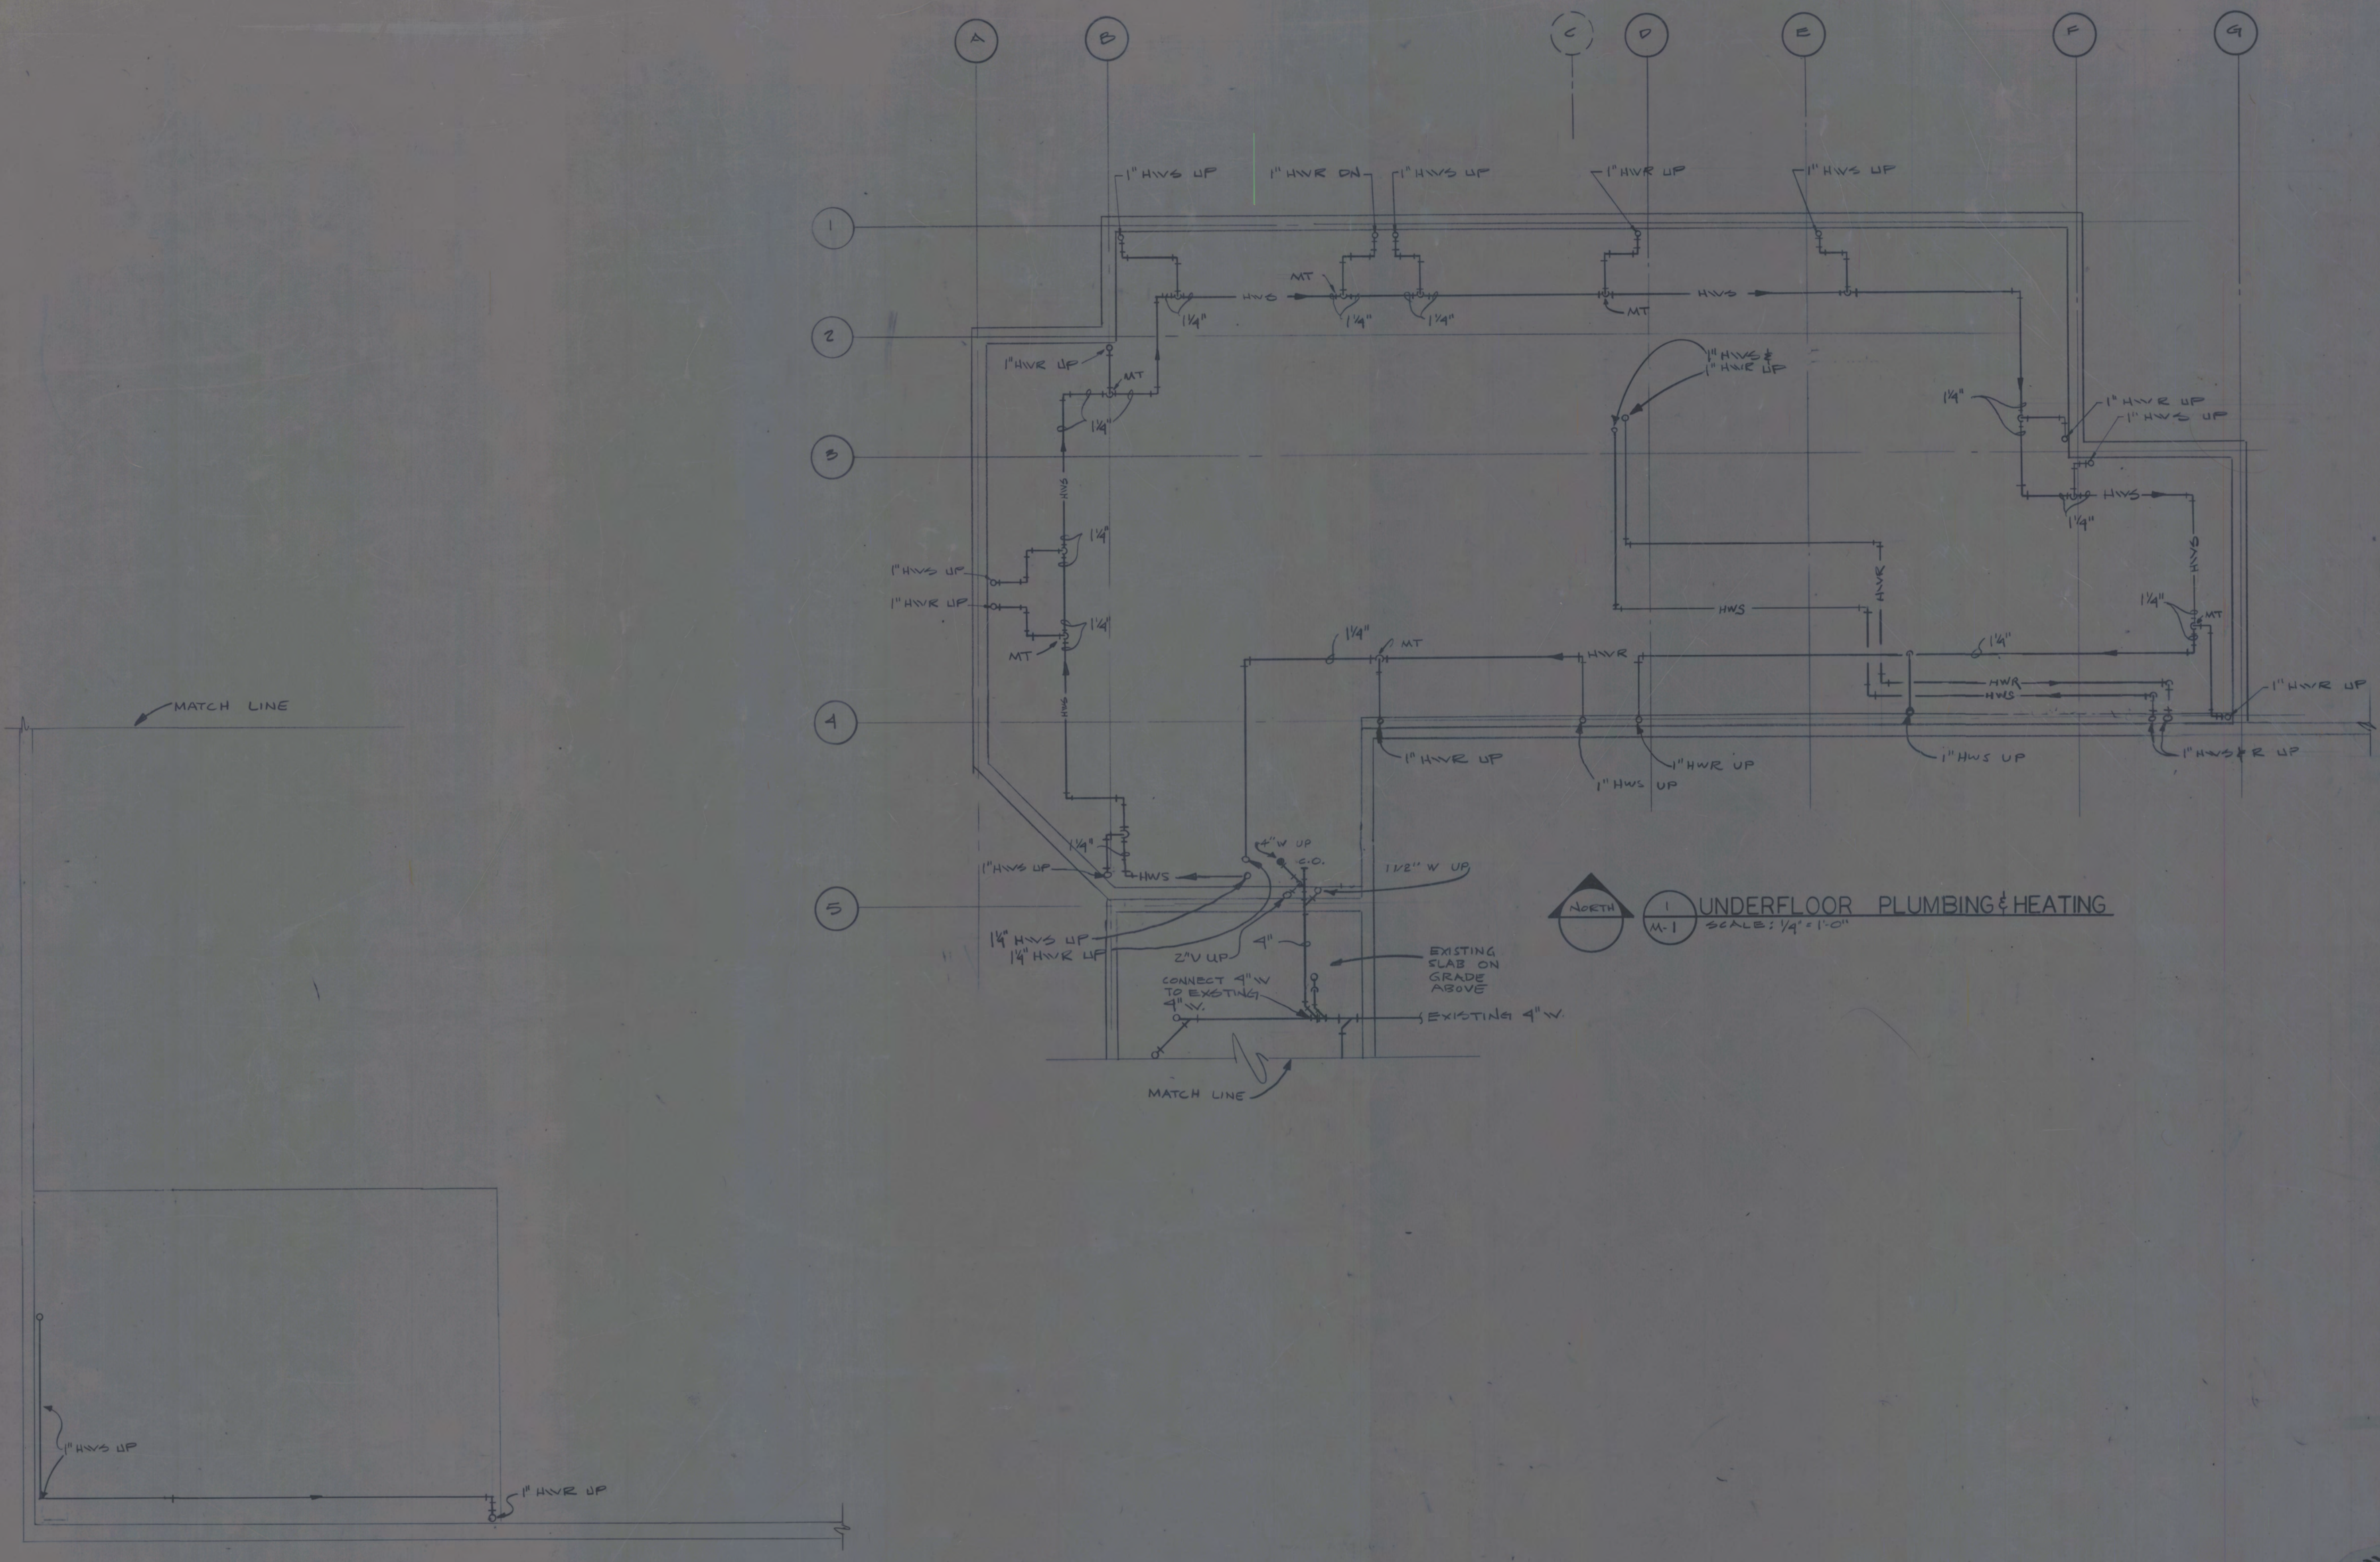

ENG7946.TIF